


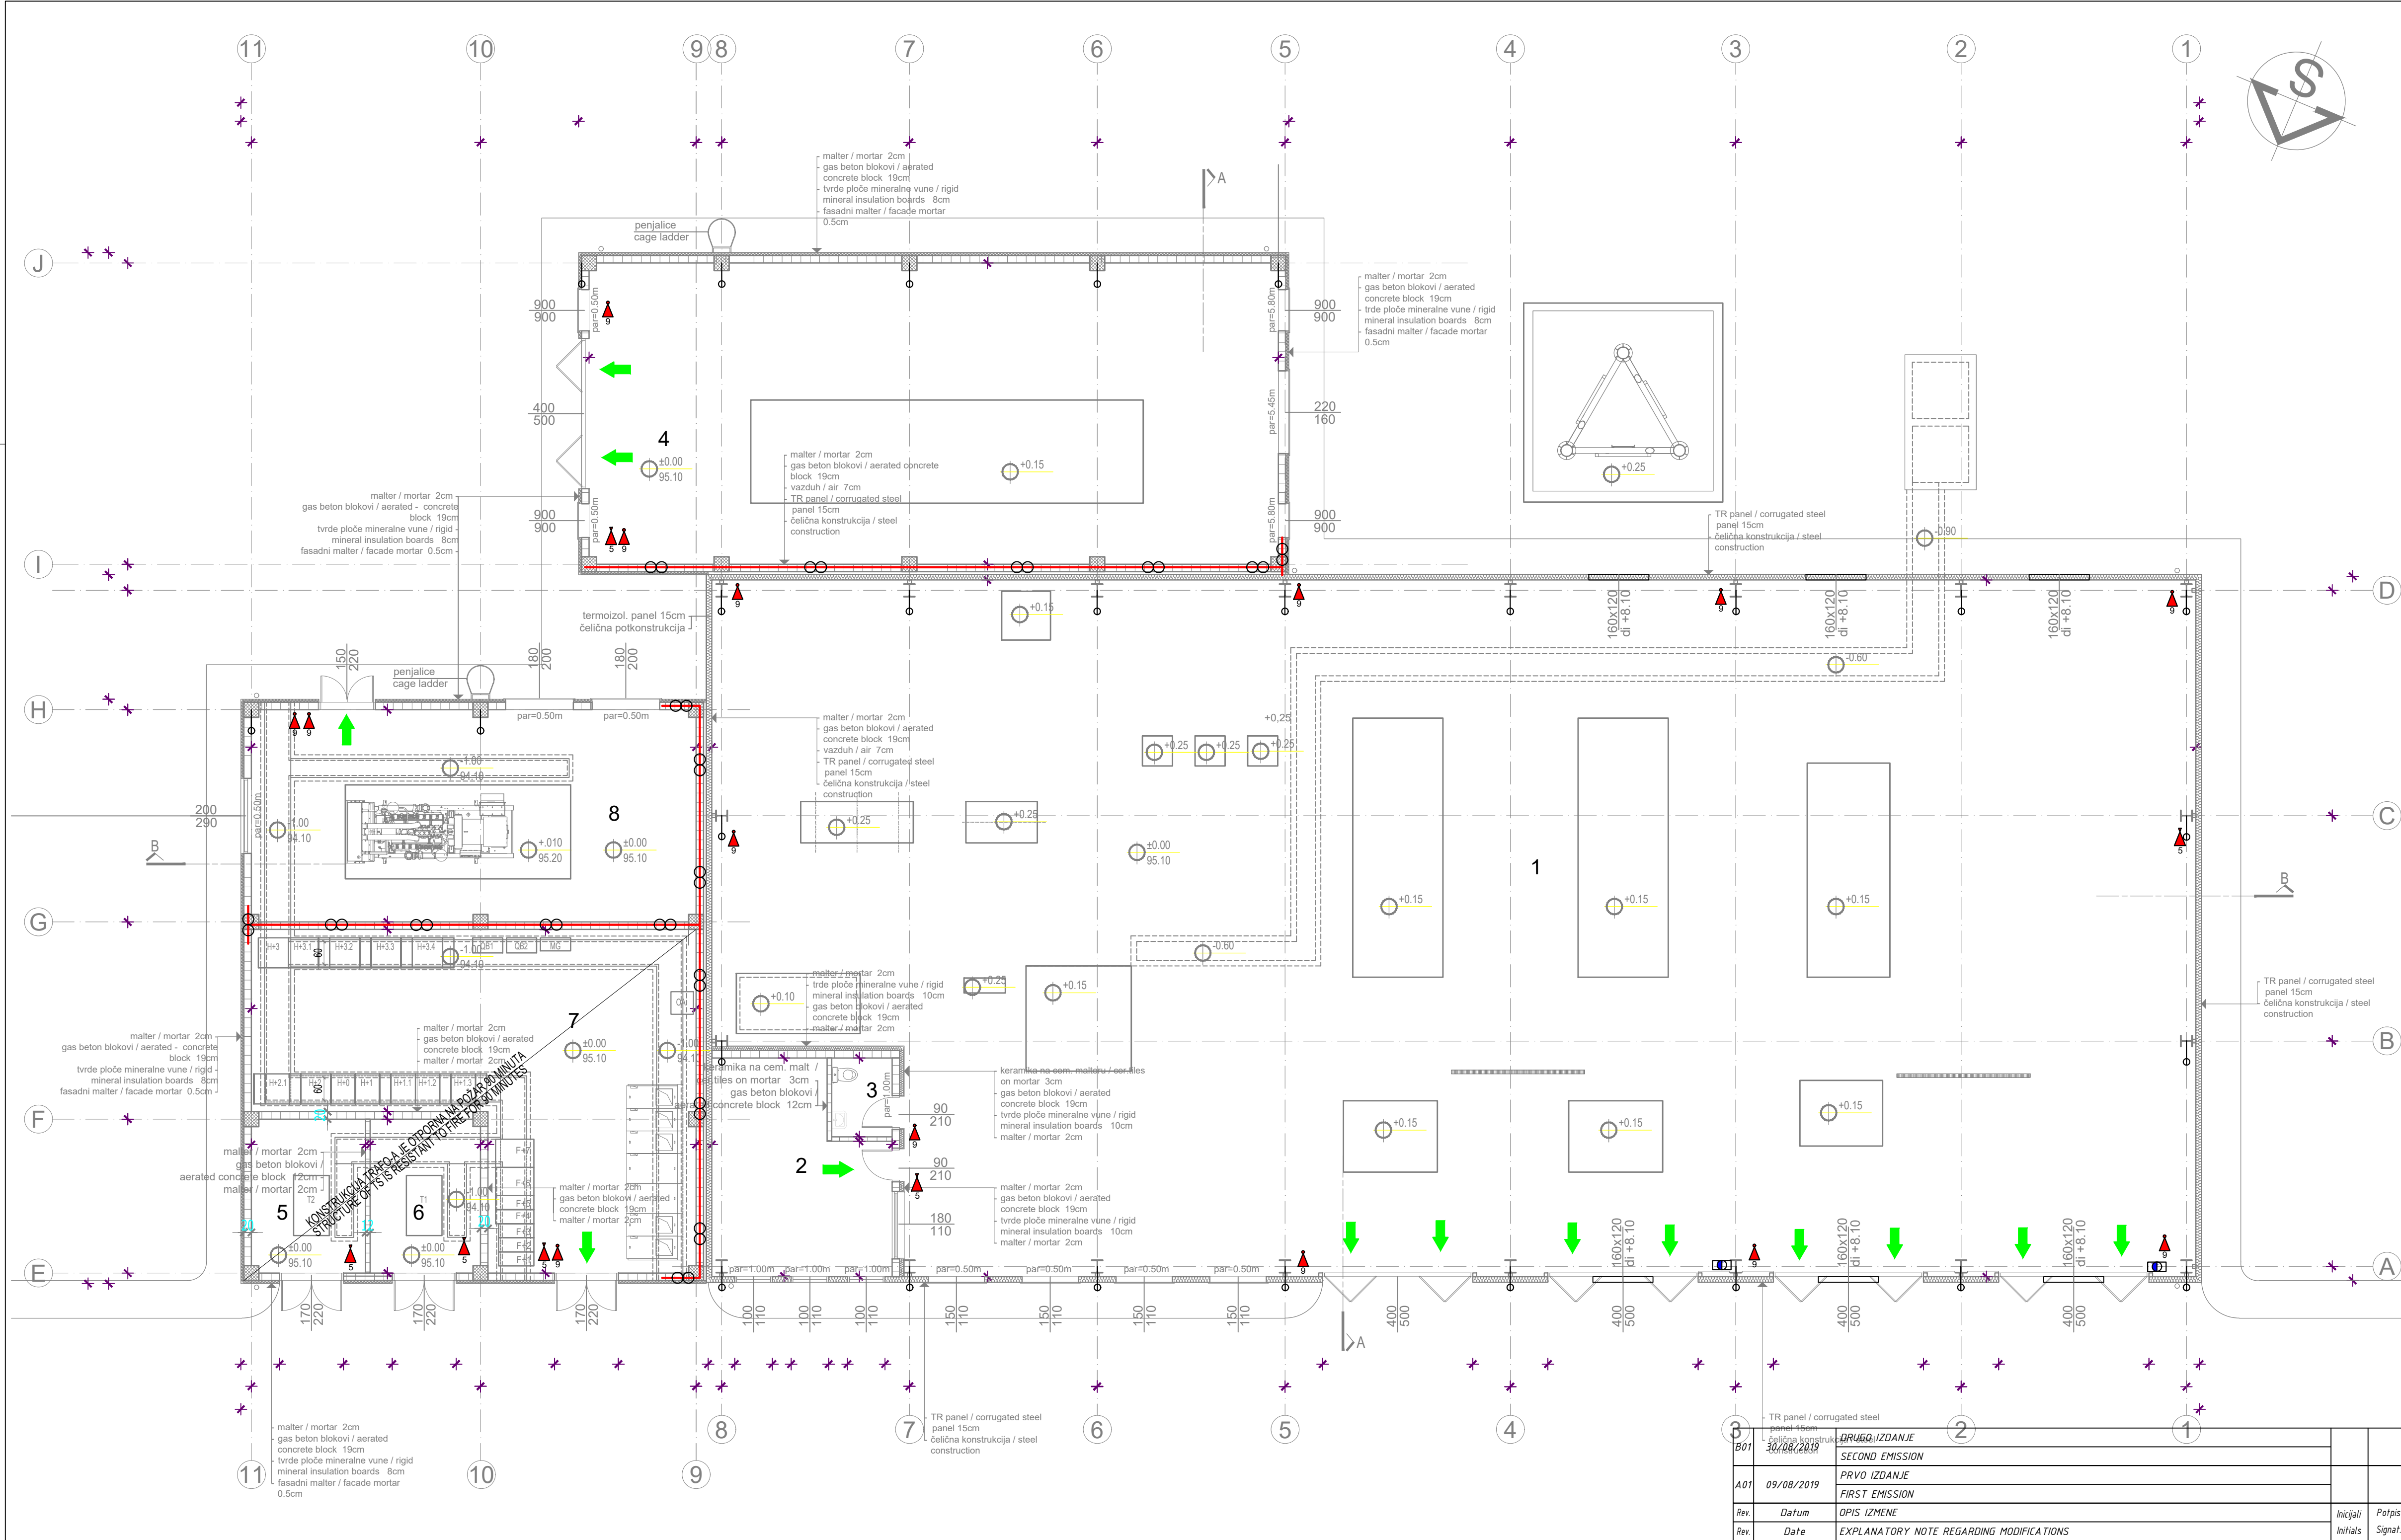

- Legenda materijala:
- armirani beton / reinforced concrete
 - blokovi od gas betona / aerated concrete blocks
 - termoizolacija / insulation
 - hidroizolacija / waterproofing
 - nearmirani beton, cementna košuljica / lean concrete, screed
 - šljunak / gravel

NIKOLA TESLA AIRPORT CONCESSION, BELGRADE - SERBIA
NIKOLA TESLA AERODROM KONCESIJA, BEOGRAD - SRBIJA

R.br.	NAMENA PROSTORIJE	površina m²
1	KOTLARNICA / BOILER ROOM	701.45
2	KOMANDNA SOBA / OPERATING ROOM	24.52
3	TOALET / TOILET	3.38
4	CHP	146.56
5	TRAFO BOKS / TRANSFORMER BOX	12.38
6	TRAFO BOKS / TRANSFORMER BOX	11.98
7	10kV I 0.4kV RAZVODNO POSTROJENJE / MV AND LV SWITCHGEAR ROOM	81.11
8	DIZEL AGREGAT / DEA	66.58
UKUPNA NETO POVRŠINA / NETT AREA		1047.95
UKUPNA BRUTO POVRŠINA / GROSS AREA		1105.17

LEGENDA PP SIMBOLA LEGEND OF FIRE - PROTECTION SYMBOLS
ZD OPOZORAV NA POŽAR 10 MINUTA (PP alarm) FIRE ALARM (FOR 10 MINUTES (PP alarm))
SUVA PRAŠNA ZA GASENJE PROJEKTOVANOG KAPACITETA (kg) DRY POWDER EXTINGUISHER WITH CAPACITY (kg) FOR EXTINGUISHING THE DESIGNED CAPACITY (kg)
VODENI ZA GASENJE PROJEKTOVANOG KAPACITETA (kg) WATER EXTINGUISHER WITH CAPACITY (kg) FOR EXTINGUISHING THE DESIGNED CAPACITY (kg)
SMER EVAKUACIJE UNUTAR OBJEKTA DIRECTION OF EVACUATION INSIDE THE BUILDING
UNUTRAŠNJI HODRANT INTERNAL HYDRANT
STUB OPOZORAV NA POŽAR 10 MINUTA COLUMN RESISTANT TO FIRE FOR 10 MINUTES

±0.00 = 96.45

REPUBLIC OF SERBIA REPRESENTED BY: PREDSTAVNIK REPUBLIKE SRBIJE:		GRANTOR / INVESTOR GRANTOR / INVESTITOR	CONCESSIONAIRE / FINANCIER KONCESIONAR / FINANSIJER
CONTRACTOR IZVOĐAČ RADOVA		SUB-CONTRACTOR PODIZVOĐAČ RADOVA	
CONTRACTOR IZVOĐAČ RADOVA		TECHNICAL CONTROL TEHNIČKA KONTROLA	OTHER OSTALO

DOCUMENT TITLE NAZIV DOKUMENTA		Osnova na koti ±0.00	
DOCUMENT CODE BROJ DOKUMENTA		ANT IDP FF LFS EPI HEP G DP P1 0002 B01	
Project Projekat	Stage Faza	Book Knjiga	Discipline Oblast
Issuer Izdavač	Location Lokacija	Level Sprat	Type Tip
Phasing Faziranje	Number Broj	Revision Revizija	

CONTRACT UGOVOR	NAME AND SURNAME IME I PREZIME	SIGNATURE POTPIS	PROJECT / OBJECT POSREDOVANJE / ZIV OBJEKTA
2619-EI/18			AIRPORT NIKOLA TESLA NEW HEATING PLANT AERODROM NIKOLA TESLA NOVA KOTLARNICA
CHIEF DESIGNER ODGOVORNI PROJEKTANT	Đorđe Regelić, dipl.maš.in Br. licence 330 J955 11		BASIC DESIGN IDEJNI PROJEKAT
ASSOCIATE DESIGNER PROJEKTANT SARADNIK	Mladen Tepurić, d.i.a. Milorad Vasiljević		WORKS DESIGN POSREDOVANJE / OBLAST
INTERNAL CONTROLLER UNUTRAŠNJA KONTROLA	Milan Ristić, d.i.m. 330 P876 18		FIRE PROTECTION STUDY ELABORAT ZAŠTITE OD POŽARA
PROJECT MANAGER SEF PROJEKTA	Stojanka Pejić, d.i.e. 350 1888 10		Ground floor Osnova prizemlja
DESIGN NUMBER / BROJ PROJEKTA	SCALE / RAZMERA	DATE / DATUM	DRAWING NUMBER / BROJ CRTEŽA
ZOP-47/2019	1:100	VIII 2019	idp FF LFS - 002
Rev. Datum		Initials Inicijali	Sheet / Strana
Rev. Date		Signal.	1