


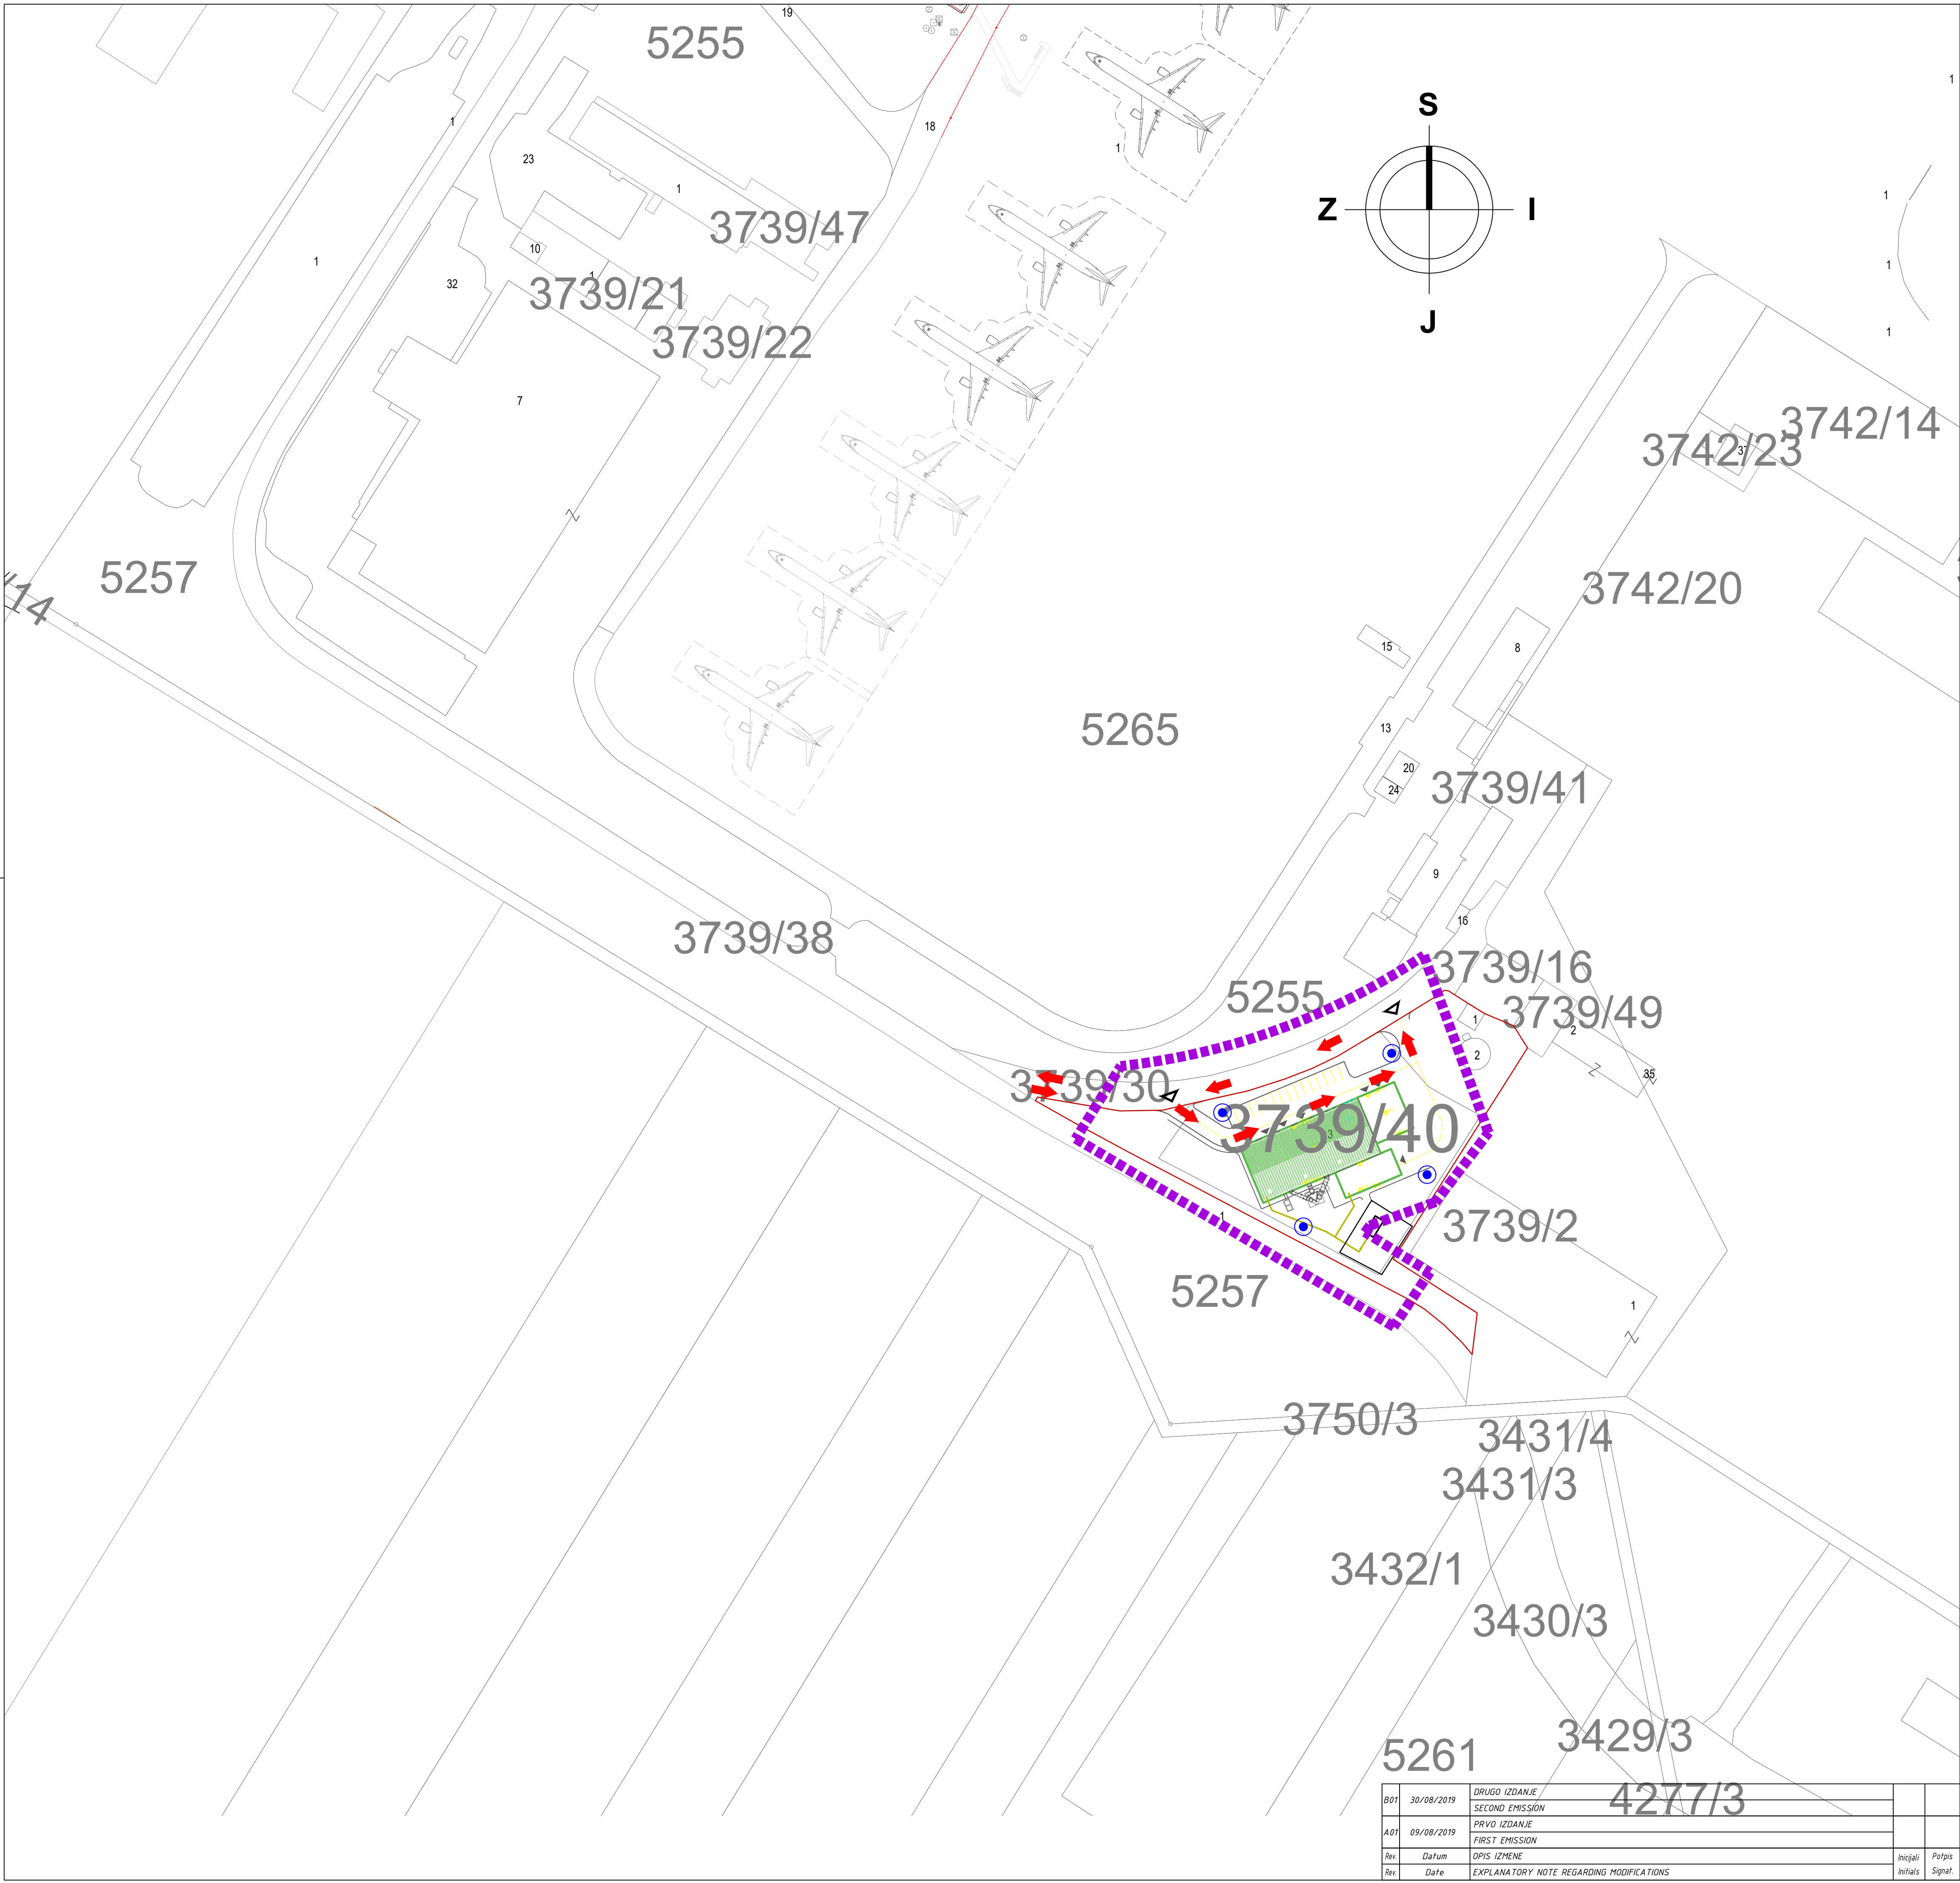

- LEGENDA
- OBJEKAT KOJI JE PREDMET OVOG PROJEKTA
 - GRANICA KATASTARSKIH PARCELA
 - GRANICA PARCELE 3739/40 NA KOJOJ SE NALAZI OBJEKAT

NIKOLA TESLA AIRPORT CONCESSION, BELGRADE - SERBIA
NIKOLA TESLA AERODROM KONCESIJA, BEOGRAD - SRBIJA

- LEGENDA PP SIMBOLA
LEGEND OF FIRE - PROTECTION SYMBOLS
- SPOLJNI HIDRANT NADZEMNI
EXTERNAL HYDRANT
 - SPOLJNI VATROGASNI PUT
EXTERIOR FIRE ENGINE ACCESS ROAD

±0.00 = 96.45

REPUBLIC OF SERBIA REPRESENTED BY: PREDSTAVNIK REPUBLIKE SRBIJE:	GRANTOR / INVESTOR GRANTOR / INVESTITOR	CONCESSIONAIRE / FINANCIER KONCESIONAR / FINANSIJER

CONTRACTOR IZVOĐAČ RADOVA	CONCESSIONAIRE KONCESIONAR	TECHNICAL CONTROL TEHNIČKA KONTROLA	OTHER OSTALO
------------------------------	-------------------------------	--	-----------------

SITE LAYOUT
SITUACIONI PLAN

ANT IDP FF LFS EPI HEP X DP P1 0001 B01

CONTRACT UGOVOR	NAME AND SURNAME IME I PREZIME	PROJECT / OBJECT NAMEN I OBJEKAT
2619-EI/18		AIRPORT NIKOLA TESLA NEW HEATING PLANT AERODROM NIKOLA TESLA NOVA KOTLARница
CHIEF DESIGNER ODGOVORNI PROJEKTANT	Dorđe Regejčić, dipl. inž. arh. Br. licence 330 J955 11	BASIC DESIGN IDEJNI PROJEKAT
ASSOCIATE DESIGNER PROJEKTANT SAPOSREDAK	Milica Tepurčić, d.i.a. Milica Vasiljević	FIRE PROTECTION STUDY ELABORAT ZAŠTITE OD POŽARA
INTERNAL CONTROLLER UNUTRAŠNJA KONTROLA	Milan Ristić, d.i.m. 330 P876 18	
PROJECT MANAGER OPIS IZMENE	Stojanka Pejčić, d.i.b. 350 I886 10	
Rev. Datum	OPIS IZMENE	INITIALS / POČETAK
Rev. Date	EXPLANATORY NOTE REGARDING MODIFICATIONS	SIGNATURE / POTPIS
DESIGN NUMBER / BROJ PROJEKTA ZOP-47/2019		SCALE / MERA 1:1000
DATE / DATUM VIII 2019		DRAWING NUMBER / BROJ CRTEŽA idp FF LFS - 001
SHEET / STRANA 1		TOTAL SHEETS / UKUPNO STRANA 1