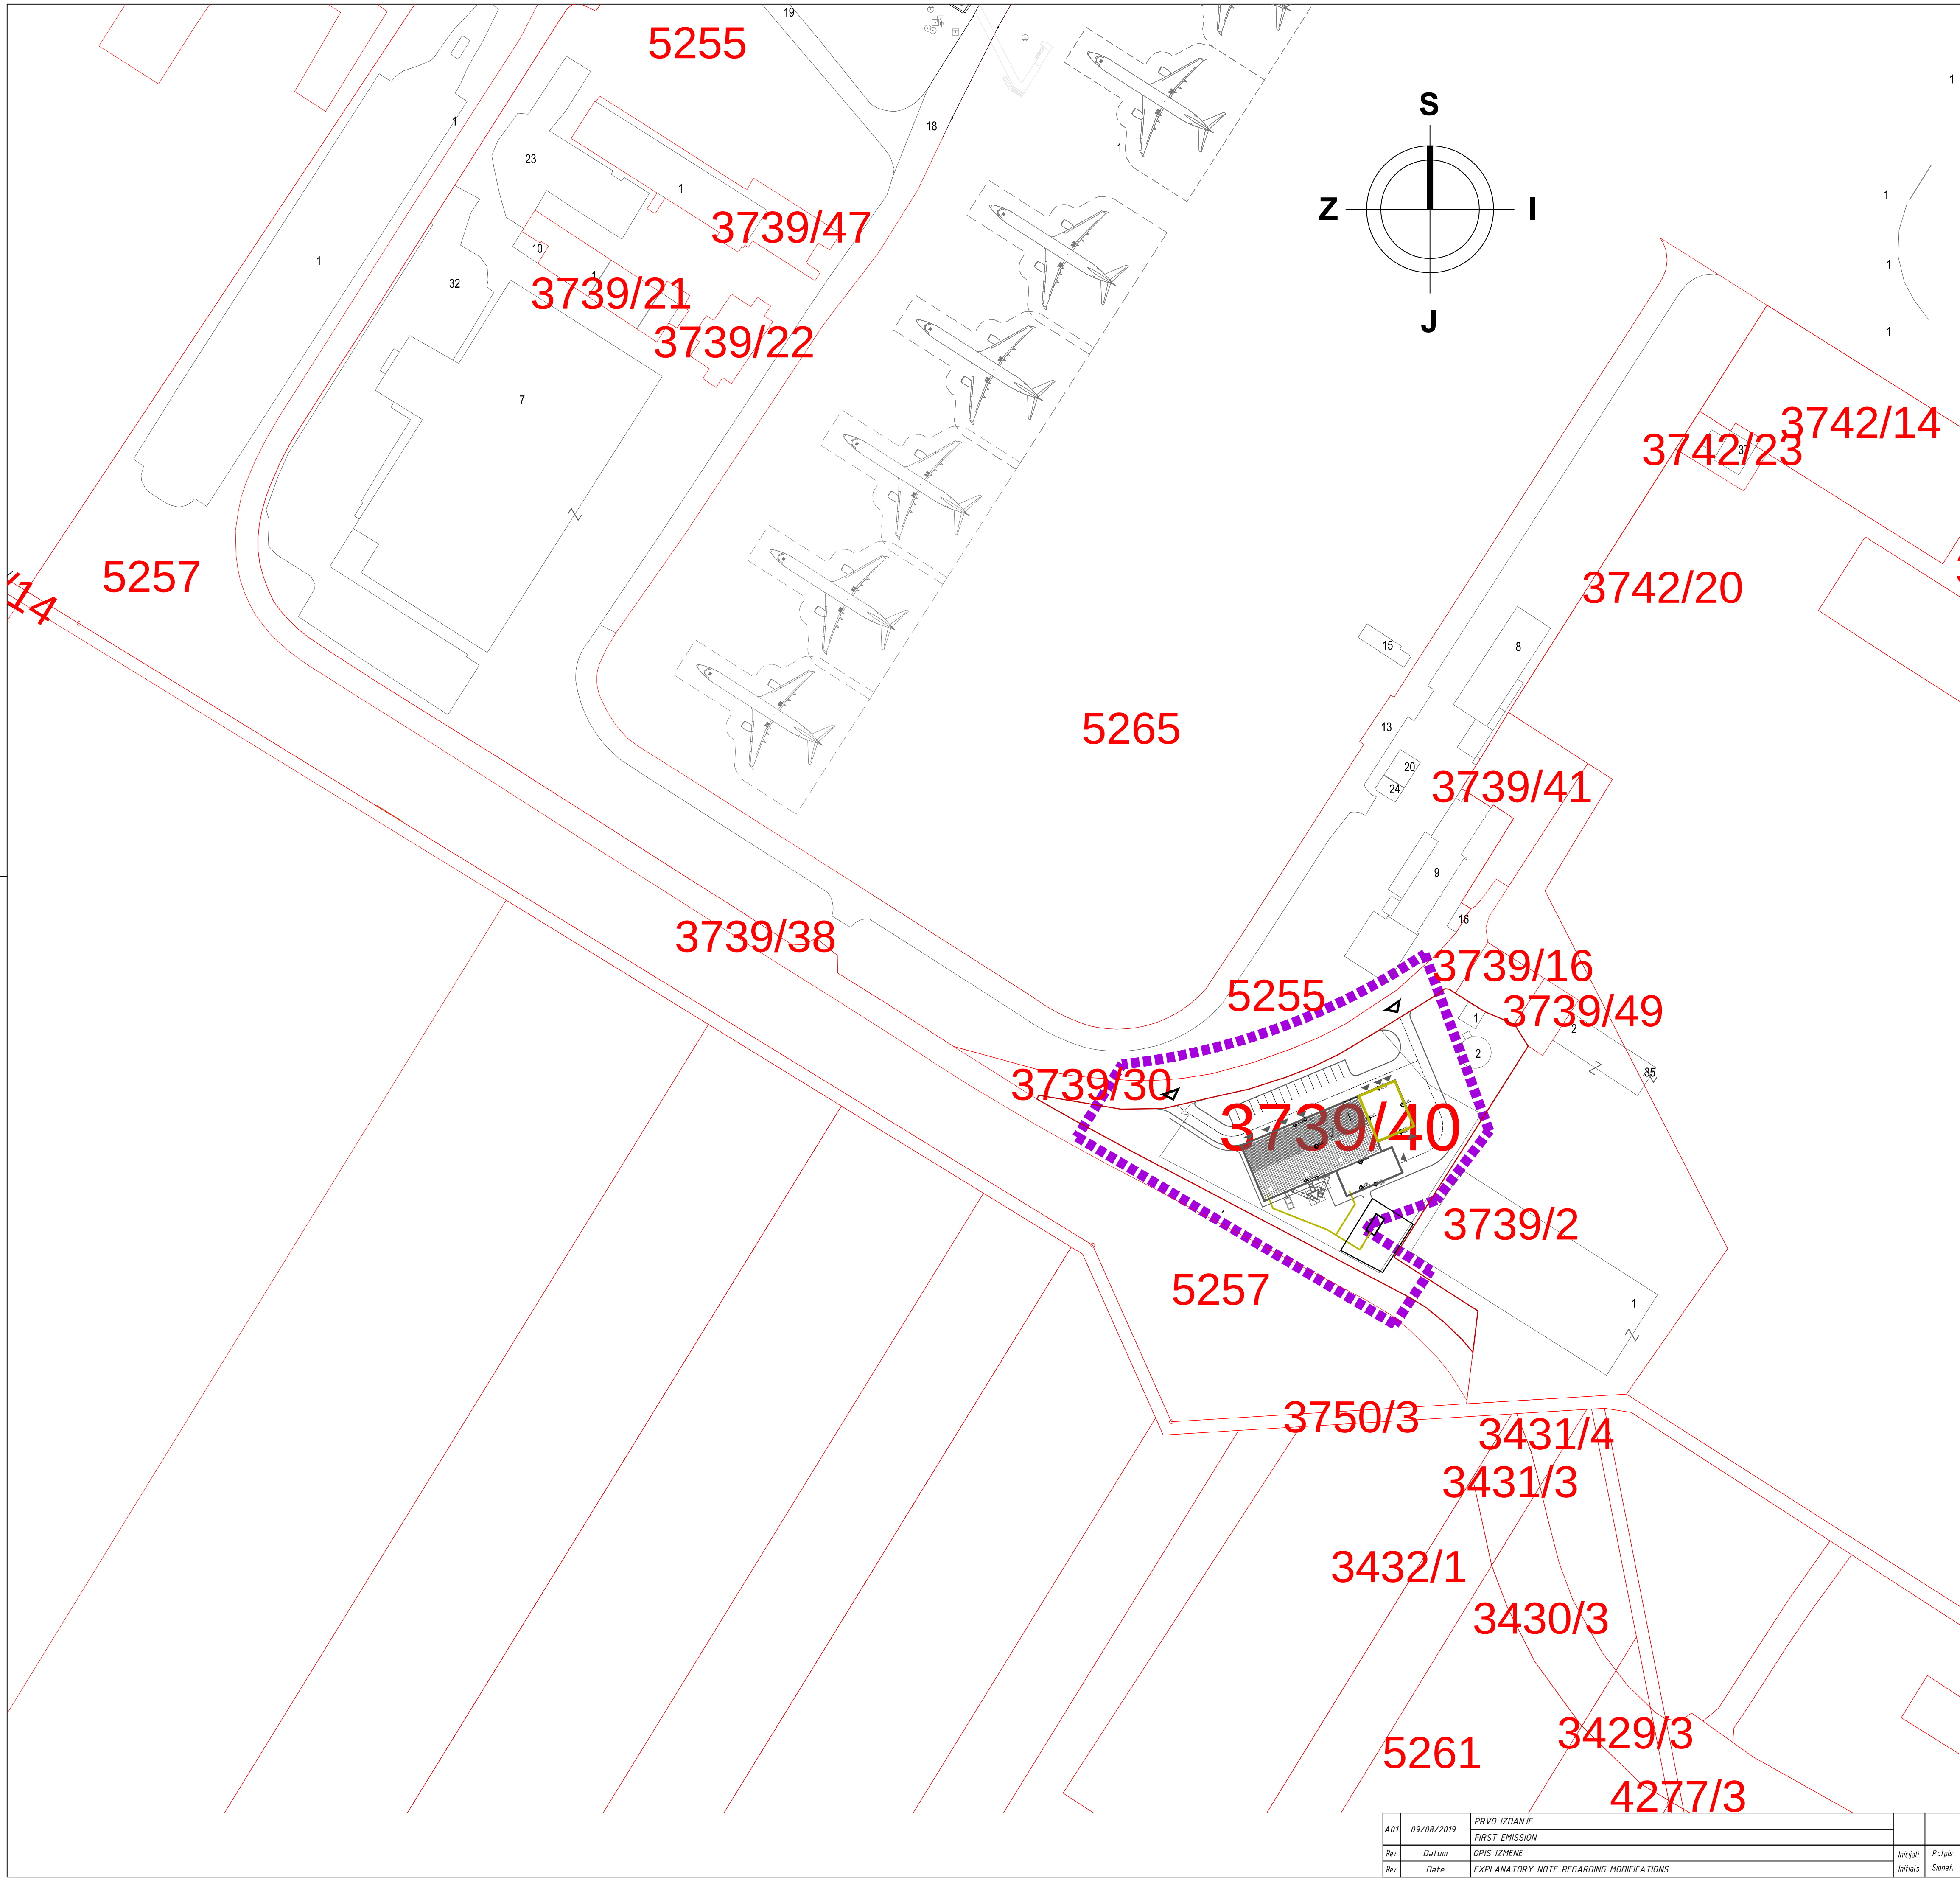




 
LEGENDA

- OBJEKAT KOJI JE PREDMET OVOG PROJEKTA
- GRANICA KATASTARSKIH PARCELA
- GRANICA PARCELE 3739/40 NA KOJOJ SE NALAZI OBJEKAT

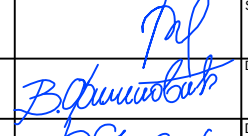
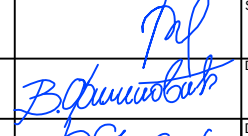
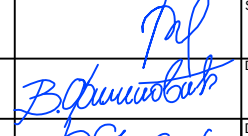
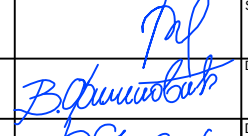
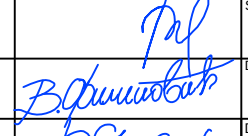
NIKOLA TESLA AIRPORT CONCESSION, BELGRADE - SERBIA
NIKOLA TESLA AERODROM KONCESIJA, BEOGRAD - SRBIJA



±0.00 = 95.10

REPUBLIC OF SERBIA REPRESENTED BY: PREDSTAVNIK REPUBLIKE SRBIJE:		GRANTOR / INVESTOR GRANTOR / INVESTITOR		CONCESSIONAIRE / FINANCIER KONCESIONAR / FINANSIJER	
					
CONTRACTOR IZVOĐAČ RADOVA		CONCESSIONAIRE KONCESIONAR		TECHNICAL CONTROL TEHNIČKA KONTROLA	
					
					

DOCUMENT TITLE NAZIV DOKUMENTA	SITE LAYOUT SITUACIONI PLAN				
DOCUMENT CODE BROJ DOKUMENTA	ANT IDP 01 ARC EPI HEP X DP P1 0001 A01				
Project Projekat	Stage Faza	Book Knjiga	Discipline Oblast	Author Emisent	Location Lokacija
Level Sprat	Type Tip	Passing Etapas	Number Broj	Revision Revizija	

CONTRACT / UGOVOR	NAME AND SURNAME IME I PREZIME	SIGNATURE POTPIS	PROJECT / OBJEKT NAZIV OBJEKTA
2619-EV18	V. Vučković Kiš, d.i.b. 300 5802 03		AIRPORT NIKOLA TESLA NEW HEATING PLANT AERODROM NIKOLA TESLA NOVA KOTLARница
CHIEF DESIGNER ODGOVORNI PROJEKTANT	V. Vučković Kiš, d.i.b. 300 5802 03		STAGE / FAZA PROJEKTA
ASSOCIATE DESIGNER PROJEKTANT SA RADOM	Vladimir Filipović i.a.		BASIC DESIGN IDEJNI PROJEKAT
INTERNAL CONTROLLER UNUTRAŠNJA KONTROLA	Katarina Stojković d.i.b. 300 1474 12		1 - Architectural design 1 - Projekat arhitekture
PROJECT MANAGER ŠEF PROJEKTA	Stojanka Pejčić, d.i.b. 350 1886 10		GENERAL LAYOUT ŠIRA SITUACIJA

A01	09/08/2019	PRVO IZDANJE			
Rev	Datum	OPIS IZMENE	Initials	Polpis	Signat
Rev	Date	EXPLANATORY NOTE REGARDING MODIFICATIONS			

DESIGN NUMBER / BROJ PROJEKTA	SCALE / MASNENA	DATE / DATUM	DRAWING NUMBER / BROJ CRTEŽA	Sheet / Strana
ZEI201918	1:1000	VIII 2019	idp 01 ARH - 001	1

ANT-IDP-01-ARC-EPI-HEP-X-DP-P1-0001-A01.dwg