


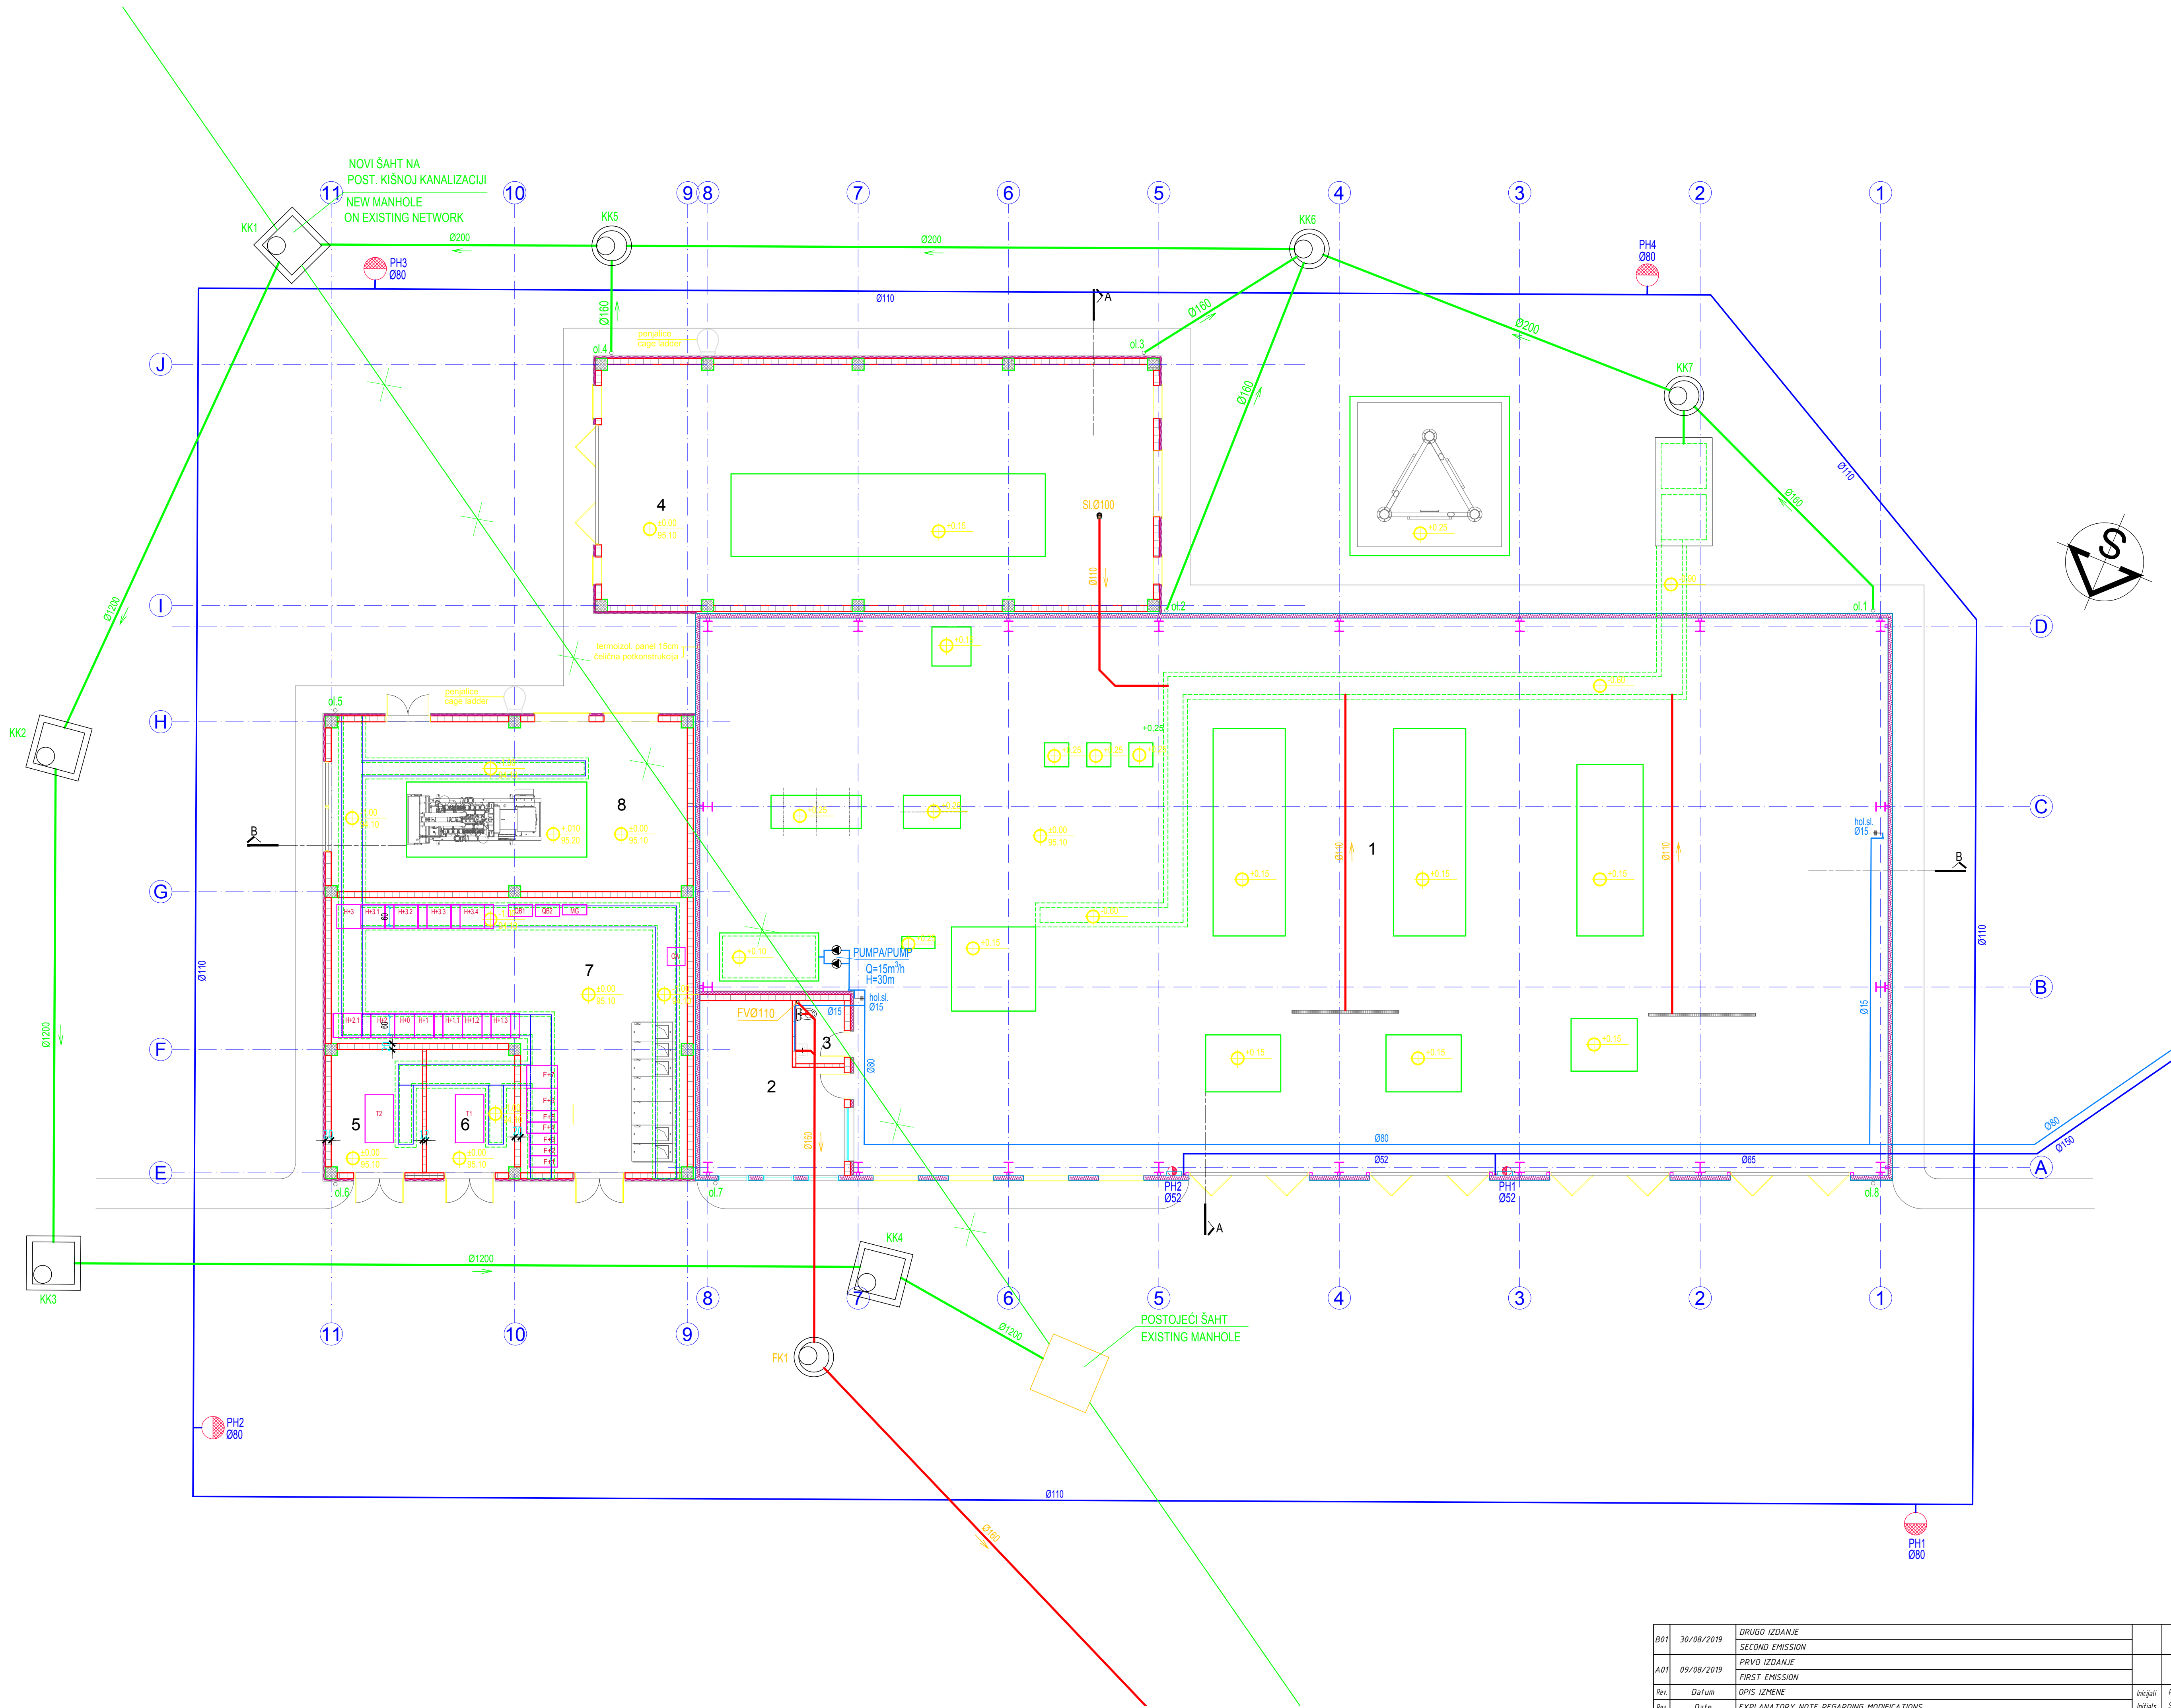

- Legenda materijala:
- amirani beton / reinforced concrete
 - blokovi od gas betona / aerated concrete blocks
 - termoizolacija / insulation
 - hidroizolacija / waterproofing
 - neamirani beton, cementna košuljica / lean concrete, screed
 - šljunak / gravel

LEGEND / LEGENDA
NEW / NOVOPROJEKTOVANO

- FOUL SEWAGE - NEW
FEKALNA KANALIZACIJA - NOVOPROJEKTOVANA
- FOUL SEWAGE - EXISTING
FEKALNA KANALIZACIJA - POSTOJEĆA
- OUTDOOR RAIN SEWAGE - NEW
SPOLJAŠNJA KIŠNA KANALIZACIJA - NOVOPROJEKTOVANA
- OUTDOOR RAIN SEWAGE - DEMOLISH
SPOLJAŠNJA KIŠNA KANALIZACIJA - UKIDA SE
- SANITARY NETWORK - NEW
SANITARNA MREŽA - NOVOPROJEKTOVANA
- HYDRANT NETWORK - NEW
HIDRANTSKA MREŽA - NOVOPROJEKTOVANA
- WATER SUPPLY NETWORK - EXISTING
VODOVODNA MREŽA - POSTOJEĆA

NIKOLA TESLA AIRPORT CONCESSION, BELGRADE - SERBIA
NIKOLA TESLA AERODROM KONCESIJA, BEOGRAD - SRBIJA

R.br.	NAMENA PROSTORIJE	površina m²
1	KOTLARNICA / BOILER ROOM	701.45
2	KOMANDNA SOBA / OPERATING ROOM	24.52
3	TOALET / TOILET	3.38
4	CHP	146.56
5	TRAFO BOKS / TRANSFORMER BOX	12.38
6	TRAFO BOKS / TRANSFORMER BOX	11.08
7	10kV I 0.4kV RAZVODNO POSTROJENJE / MV AND LV SWITCHGEAR ROOM	81.11
8	DIZEL AGREGAT / DEA	66.58
UKUPNA NETO POVRŠINA / NETT AREA		1047.95
UKUPNA BRUTO POVRŠINA / GROSS AREA		1105.17

±0.00 = 96.45

REPUBLIC OF SERBIA REPRESENTED BY: PREDSTAVNIK REPUBLIKE SRBIJE	GRANTOR / INVESTOR AERODROM Nikola Tesla Beograd	CONCESSIONAIRE / FINANCIER KONCESIONARNI FINANSIJER BELGRADE AIRPORT BELGRADE AIRPORT d.o.o. 11180 Beograd 59, Surčin
--	---	---

VINCI	GRANDS PROJECTS	TERNA	ENERGOPROJEKT INDUSTRY P.L.C. BELGRADE, SERBIA
-------	-----------------	-------	--

STATUS	STATUS	STATUS	STATUS
CONTRACTOR IZVOĐAČ RADOVA	CONCESSIONAIRE KONCESIONAR	TECHNICAL CONTROL TEHNIČKA KONTROLA	OTHER OSTALO

Floor layout at elevation ±0.00
Osnova na koti ±0.00

PROJECT / OBJEKT AIRPORT NIKOLA TESLA NEW HEATING PLANT AERODROM NIKOLA TESLA NOVA KOTLARNICA	BASIC DESIGNER 3 - Projekt hidrotehničkih instalacija
---	--

CONTRACT / UGOVOR 2619-EU/18	DESIGNER / DIZAJNER D. Jarićević, d.i.g. 314 1266 09	DATE / DATUM VIII 2019
---------------------------------	--	---------------------------

ASSOCIATE DESIGNER PROJEKTANT SARADNIK S. Popović, grad. teh.	INTERNAL CONTROLLER UNUTRAŠNJA KONTROLA A. Kostić, d.i.g. 314 1266 09	PROJECT MANAGER REP. PROJEKTA Stojanica Pejčić, d.i.e. 350 1886 10
---	--	---

DESIGN NUMBER / BROJ PROJEKTA ZEI201918	SCALE / MŠKALA 1:100	DRAWING NUMBER / BROJ CRTEŽA Idp 3 HI-002
--	-------------------------	--

Rev	Datum	OPIS IZMENE	Initials	Signature
Rev	Date	EXPLANATORY NOTE REGARDING MODIFICATIONS	Initials	Signature