


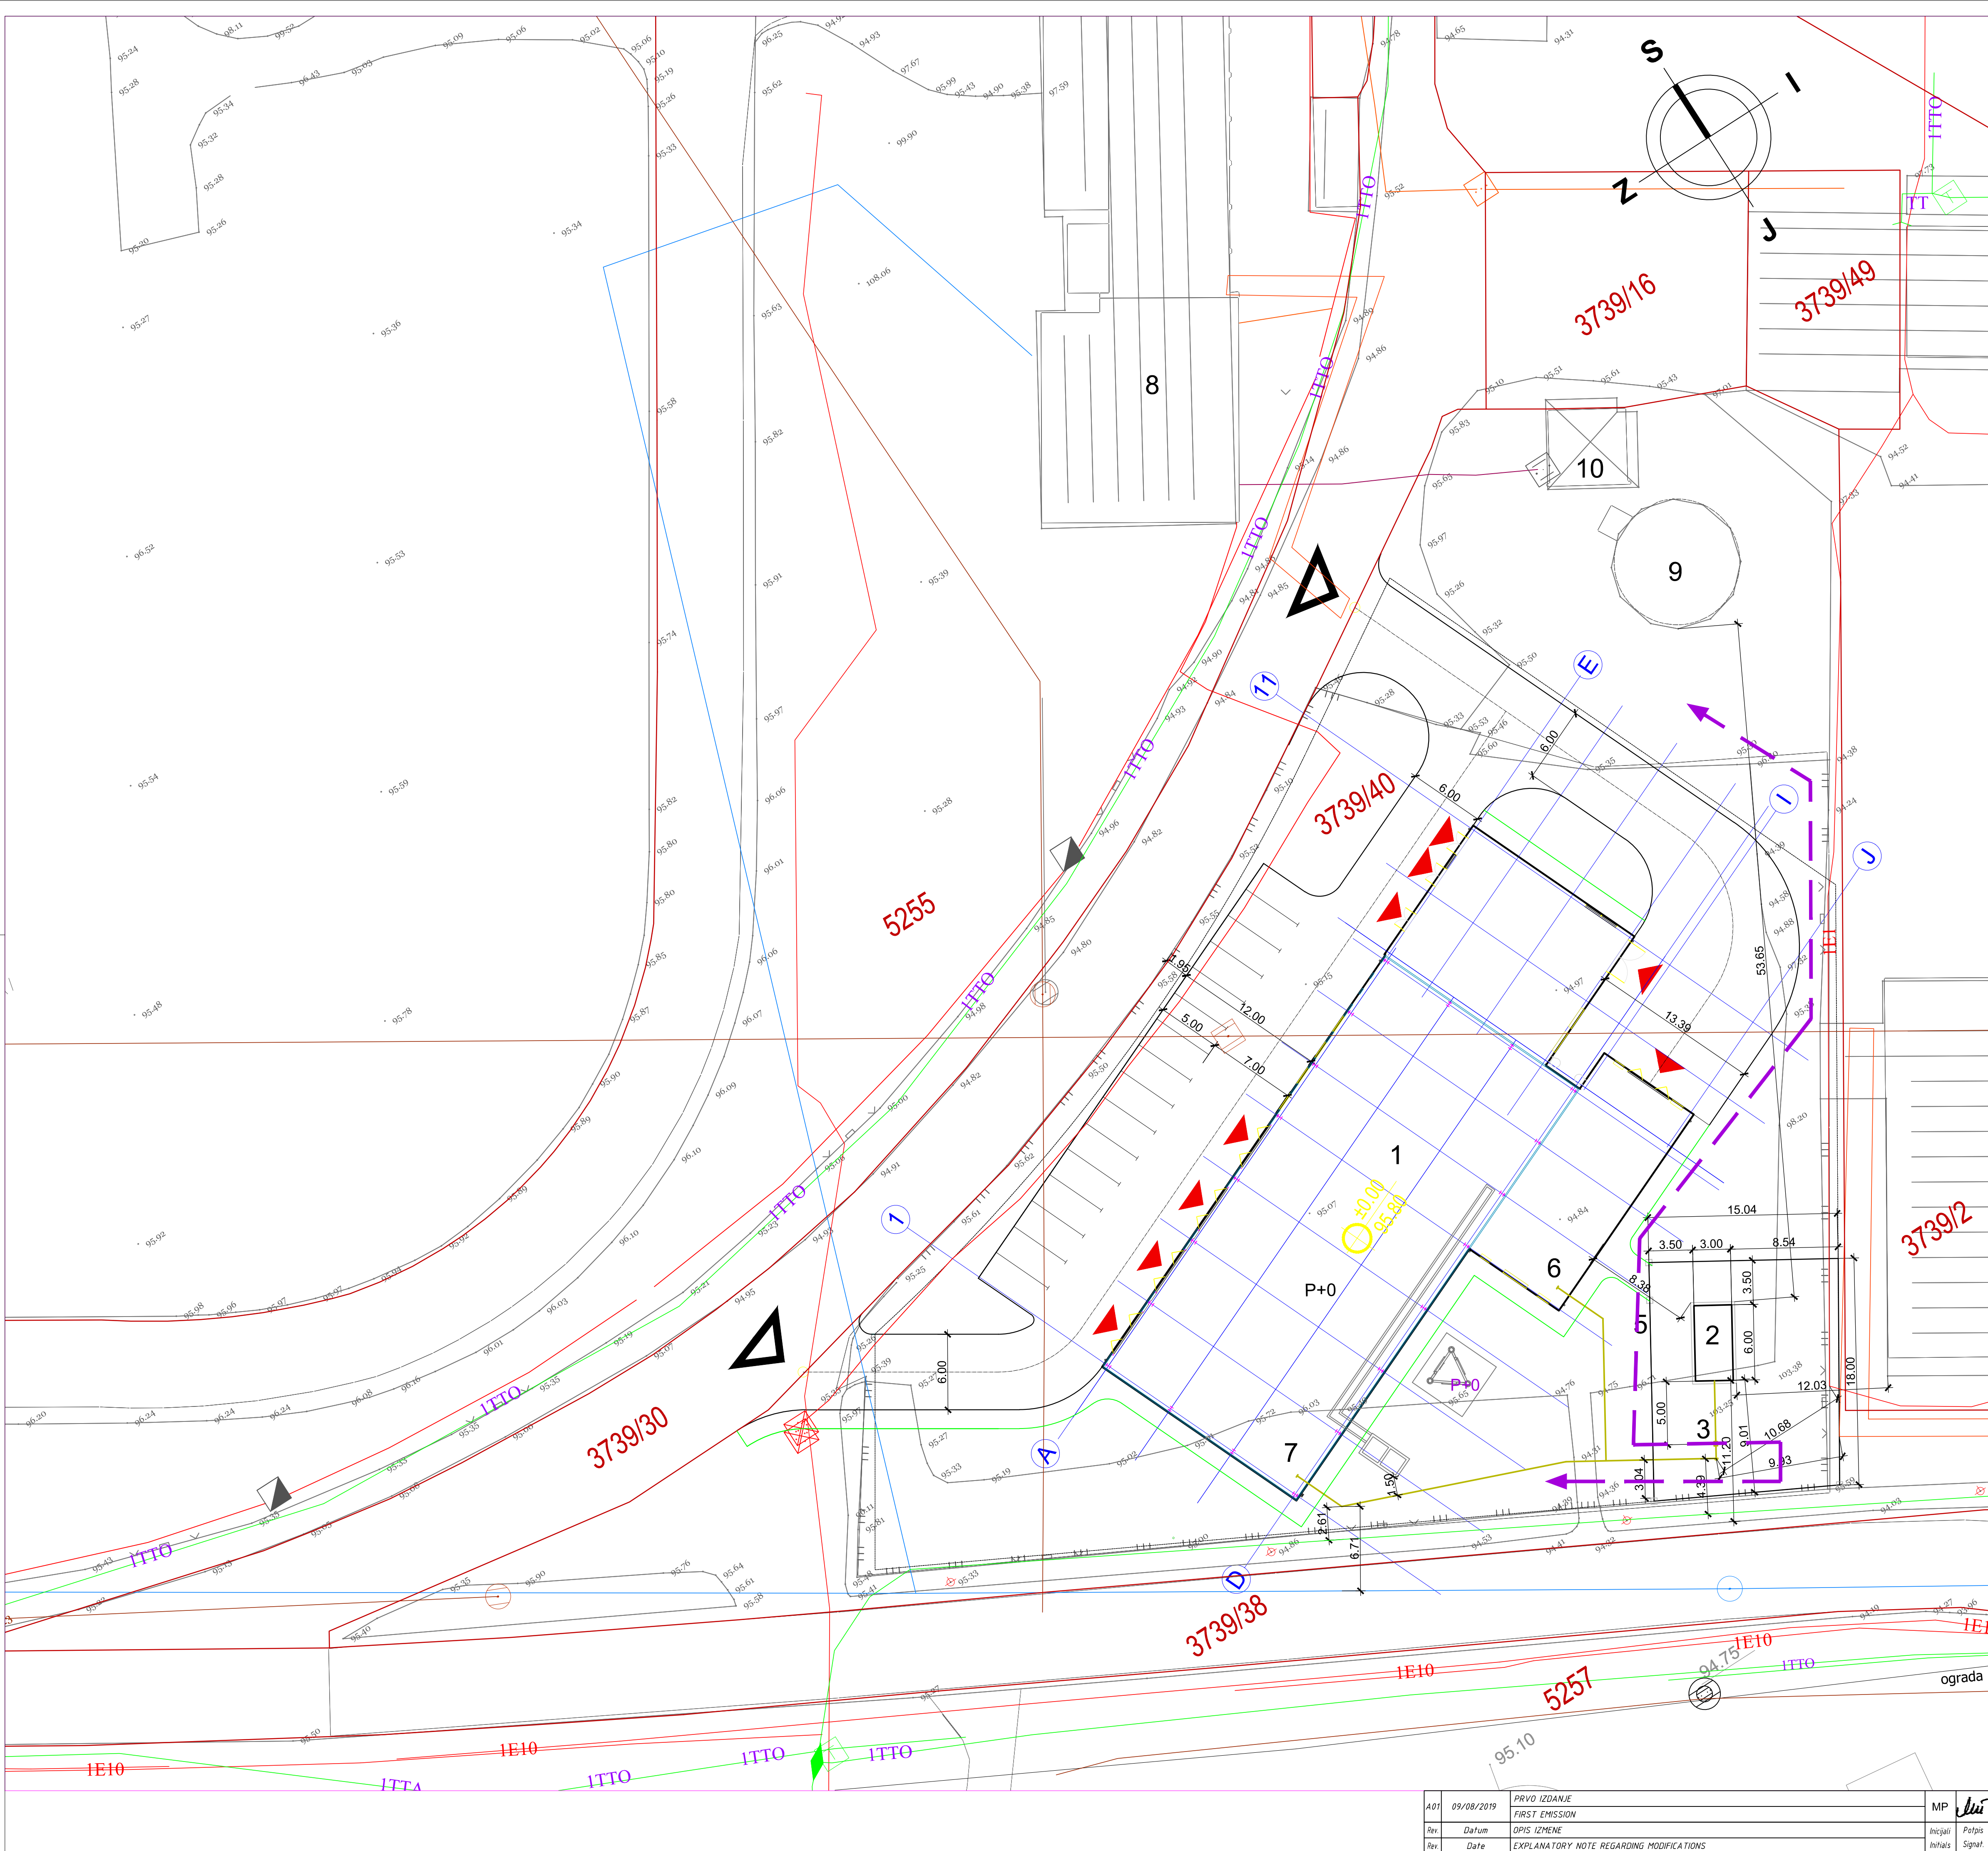

LEGENDA

- NOVA KOTLARNICA
- MERNO-REGULACIONA STANICA MRS AERODROM
- PROTIVPOŽARNI VENTIL
- SUSEDNI OBJEKAT
- OGRADA MRS
- PRIKLJUČAK ZA CHP
- PRIKLJUČAK ZA KOTLARNICU
- STARA KOTLARNICA
- REZERVOAR MAZUTA
- PREPUMNA STANICA

INSTALACIJE

- NOVI RAZVOD GASA NA PARCELI
- VODOVOD
- KANALIZCIJA
- TOPLOVOD
- E1 ELEKTRO-ENERGETSKA MREŽA - 1kv i 3kv kabl
- E10 ELEKTRO-ENERGETSKA MREŽA - 10kv kabl
- TT, TTA, TTO TELEKOMUNIKACIONI OPTIČKI KABL



NIKOLA TESLA AIRPORT CONCESSION, BELGRADE - SERBIA
NIKOLA TESLA AERODROM KONCESIJA, BEOGRAD - SRBIJA



±0.00 = 96.45

REPUBLIC OF SERBIA REPRESENTED BY: PREDSTAVNIK REPUBLIKE SRBIJE	GRANTOR / INVESTOR GRANTOR / INVESTITOR	CONCESSIONAIRE / FINANCER KONCESIONAR / FINANSIJER

CONTRACTOR IZVOĐAČ RADOVA	CONCESSIONAIRE KONCESIONAR	TECHNICAL CONTROL TEHNIČKA KONTROLA	OTHER OSTALO
CONTRACTOR IZVOĐAČ RADOVA	CONCESSIONAIRE KONCESIONAR	TECHNICAL CONTROL TEHNIČKA KONTROLA	OTHER OSTALO

GENERAL LAYOUT - MICRO LOCATION
SITUACIJA - MIKROLOKACIJA

DOCUMENT CODE BROJ DOKUMENTA	PROJECT TITLE NAZIV DOKUMENTA
ANT IDP 04 ELE EPI HEP X DP P1 0001 A01	GENERAL LAYOUT - MICRO LOCATION SITUACIJA - MIKROLOKACIJA

CONTRACT UGOVOR	NAME AND SURNAME IME I PREZIME	SIGNATURE POTPIS	PROJECT / OBJECT NAZIV OBJEKTA
2619-EI/18	M. Počuča Marković, d.o.o.		AIRPORT NIKOLA TESLA NEW HEATING PLANT AERODROM NIKOLA TESLA NOVA KOTLARNICA
CHIEF DESIGNER ODGOVORNI PROJEKTANT	M. Počuča Marković, d.o.o.		BASIC DESIGN IDEJNI PROJEKAT
ASSOCIATE DESIGNER PROJEKTANT SAPOSREDOVANJE	Milena Čučuković, d.o.o.		4 - Power supply Installations and Automatisation design 4 - Projekat elektroenergetskih instalacija i automatike
INTERNAL CONTROLLER UNUTRAŠNJA KONTROLA	Stojanka Pejčić, d.o.o.		GENERAL LAYOUT - MICRO LOCATION SITUACIJA - MIKROLOKACIJA
PROJECT MANAGER ŠEF PROJEKTA	Stojanka Pejčić, d.o.o.		GENERAL LAYOUT - MICRO LOCATION SITUACIJA - MIKROLOKACIJA
DESIGN NUMBER / BROJ PROJEKTA	SCALE / RAZMERA	DATE / DATUM	DRAWING NUMBER / BROJ CRTEŽA
ZEI201918	1:200	VIII 2019	Idp 4 EEN - 001

A01	09/08/2019	PRVO IZDANJE	MP	
Rev	Datum	FIRST EMISSION	Initials	Potpis
Rev	Date	EXPLANATORY NOTE REGARDING MODIFICATIONS	Initials	Signat.