


LAYOUT AT LEVEL ±0,00

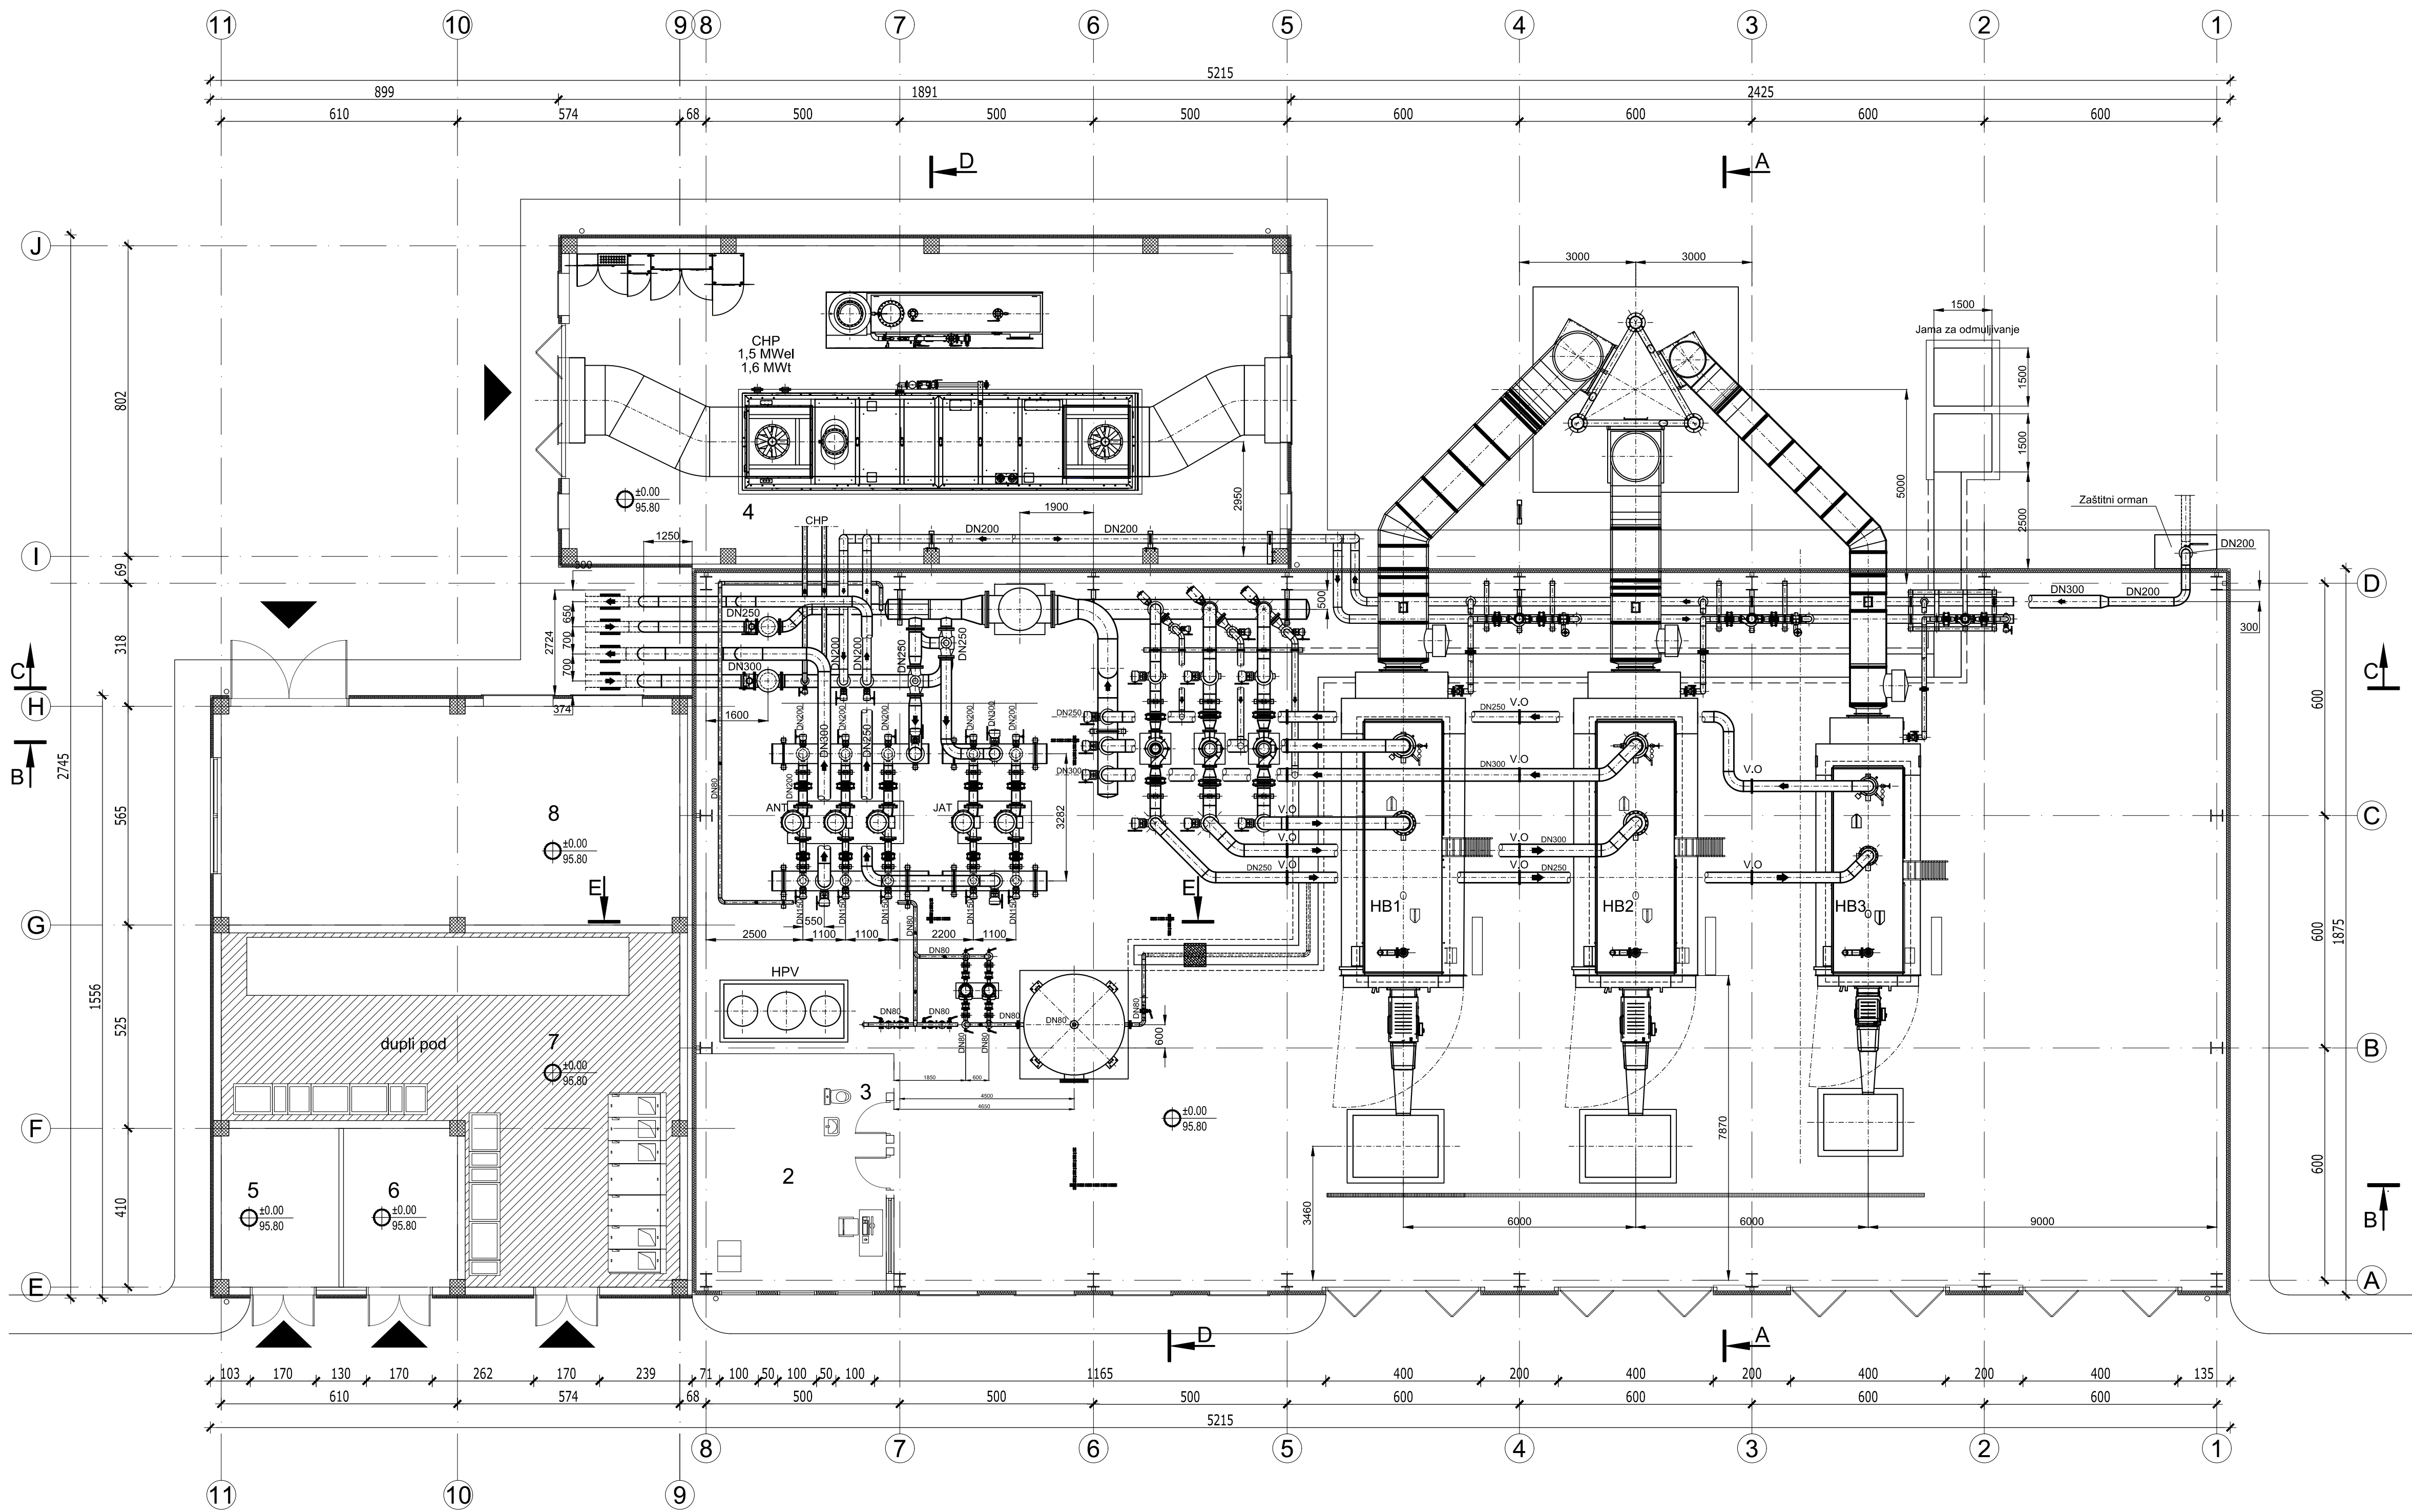

R.br.	NAMENA PROSTORIJE	površina m²
1	KOTLARNA / BOILER ROOM	701.61
2	KOMANDNA SOBA / OPERATING ROOM	####
3	TOALET / TOILET	####
4	CHP	146.56
5	TRAFO BOKS / TRANSFORMER BOX	12.39
6	TRAFO BOKS / TRANSFORMER BOX	11.98
7	10kV 10.4kV RAZVODNO POSTROJENJE / MV AND LV SWITCHGEAR ROOM	81.08
8	DIZEL AGREGAT / DEA	66.58
UKUPNA NETO POVRŠINA / NETT AREA		1020.19
UKUPNA BRUTO POVRŠINA / GROSS AREA		1101.03

NIKOLA TESLA AIRPORT CONCESSION, BELGRADE - SERBIA
NIKOLA TESLA AERODROM KONCESIJA, BEOGRAD - SRBIJA

REPUBLIC OF SERBIA REPRESENTED BY: PREDSTAVNIK REPUBLIKE SRBIJE	GRANTOR / INVESTOR GRANTOR / INVESTITOR	CONCESSIONAIRE / FINANCIER KONCESIONAR / FINANSIJER
	CONTRACTOR IZVOĐAČ RADOVA	SUB-CONTRACTOR PODIZVOĐAČ RADOVA
CONTRACTOR IZVOĐAČ RADOVA	CONCESSIONAIRE KONCESIONAR	TECHNICAL CONTROL TEHNIČKA KONTROLA
		OTHER OSTALO

LAYOUT AT LEVEL ±0,00
OSNOVA NA KOTI ±0,00

ANT IDP 64 THP EPI HEP G DP P1 0003 A01

CONTRACT UGOVOR	NAME AND SURNAME IME I PREZIME	PROJECT / OBJECT NAZIV OBJEKTA
2619-EI/18	Stevio Ilić, d.l.m. 330 8624 04	AIRPORT NIKOLA TESLA NEW HEATING PLANT AERODROM NIKOLA TESLA NOVA KOTLARNA
CHIEF DESIGNER ODGOVORNI PROJEKTANT	DESIGNER'S ASSOCIATE SARADNIK	STAGE / FASE PROJEKTA
Vladan Obradović, d.l.m. 330 3911 03	Stojanka Pejčić, d.l.e. 350 1886 10	BASIC DESIGN IDEJNI PROJEKAT
INTERNAL CONTROLLER UNUTRAŠNJA KONTROLA	PROJECT MANAGER ŠEF PROJEKTA	6/2 - Thermal Power Design 6/2 - Projekat termoelektrike
ZEI201918	SCALE / RAZMERA 1:100	DATE / DATUM VIII 2019
		DRAWING NUMBER / BROJ CRTEŽA idp 6/2 MST - 003
		Sheet / Strana 1