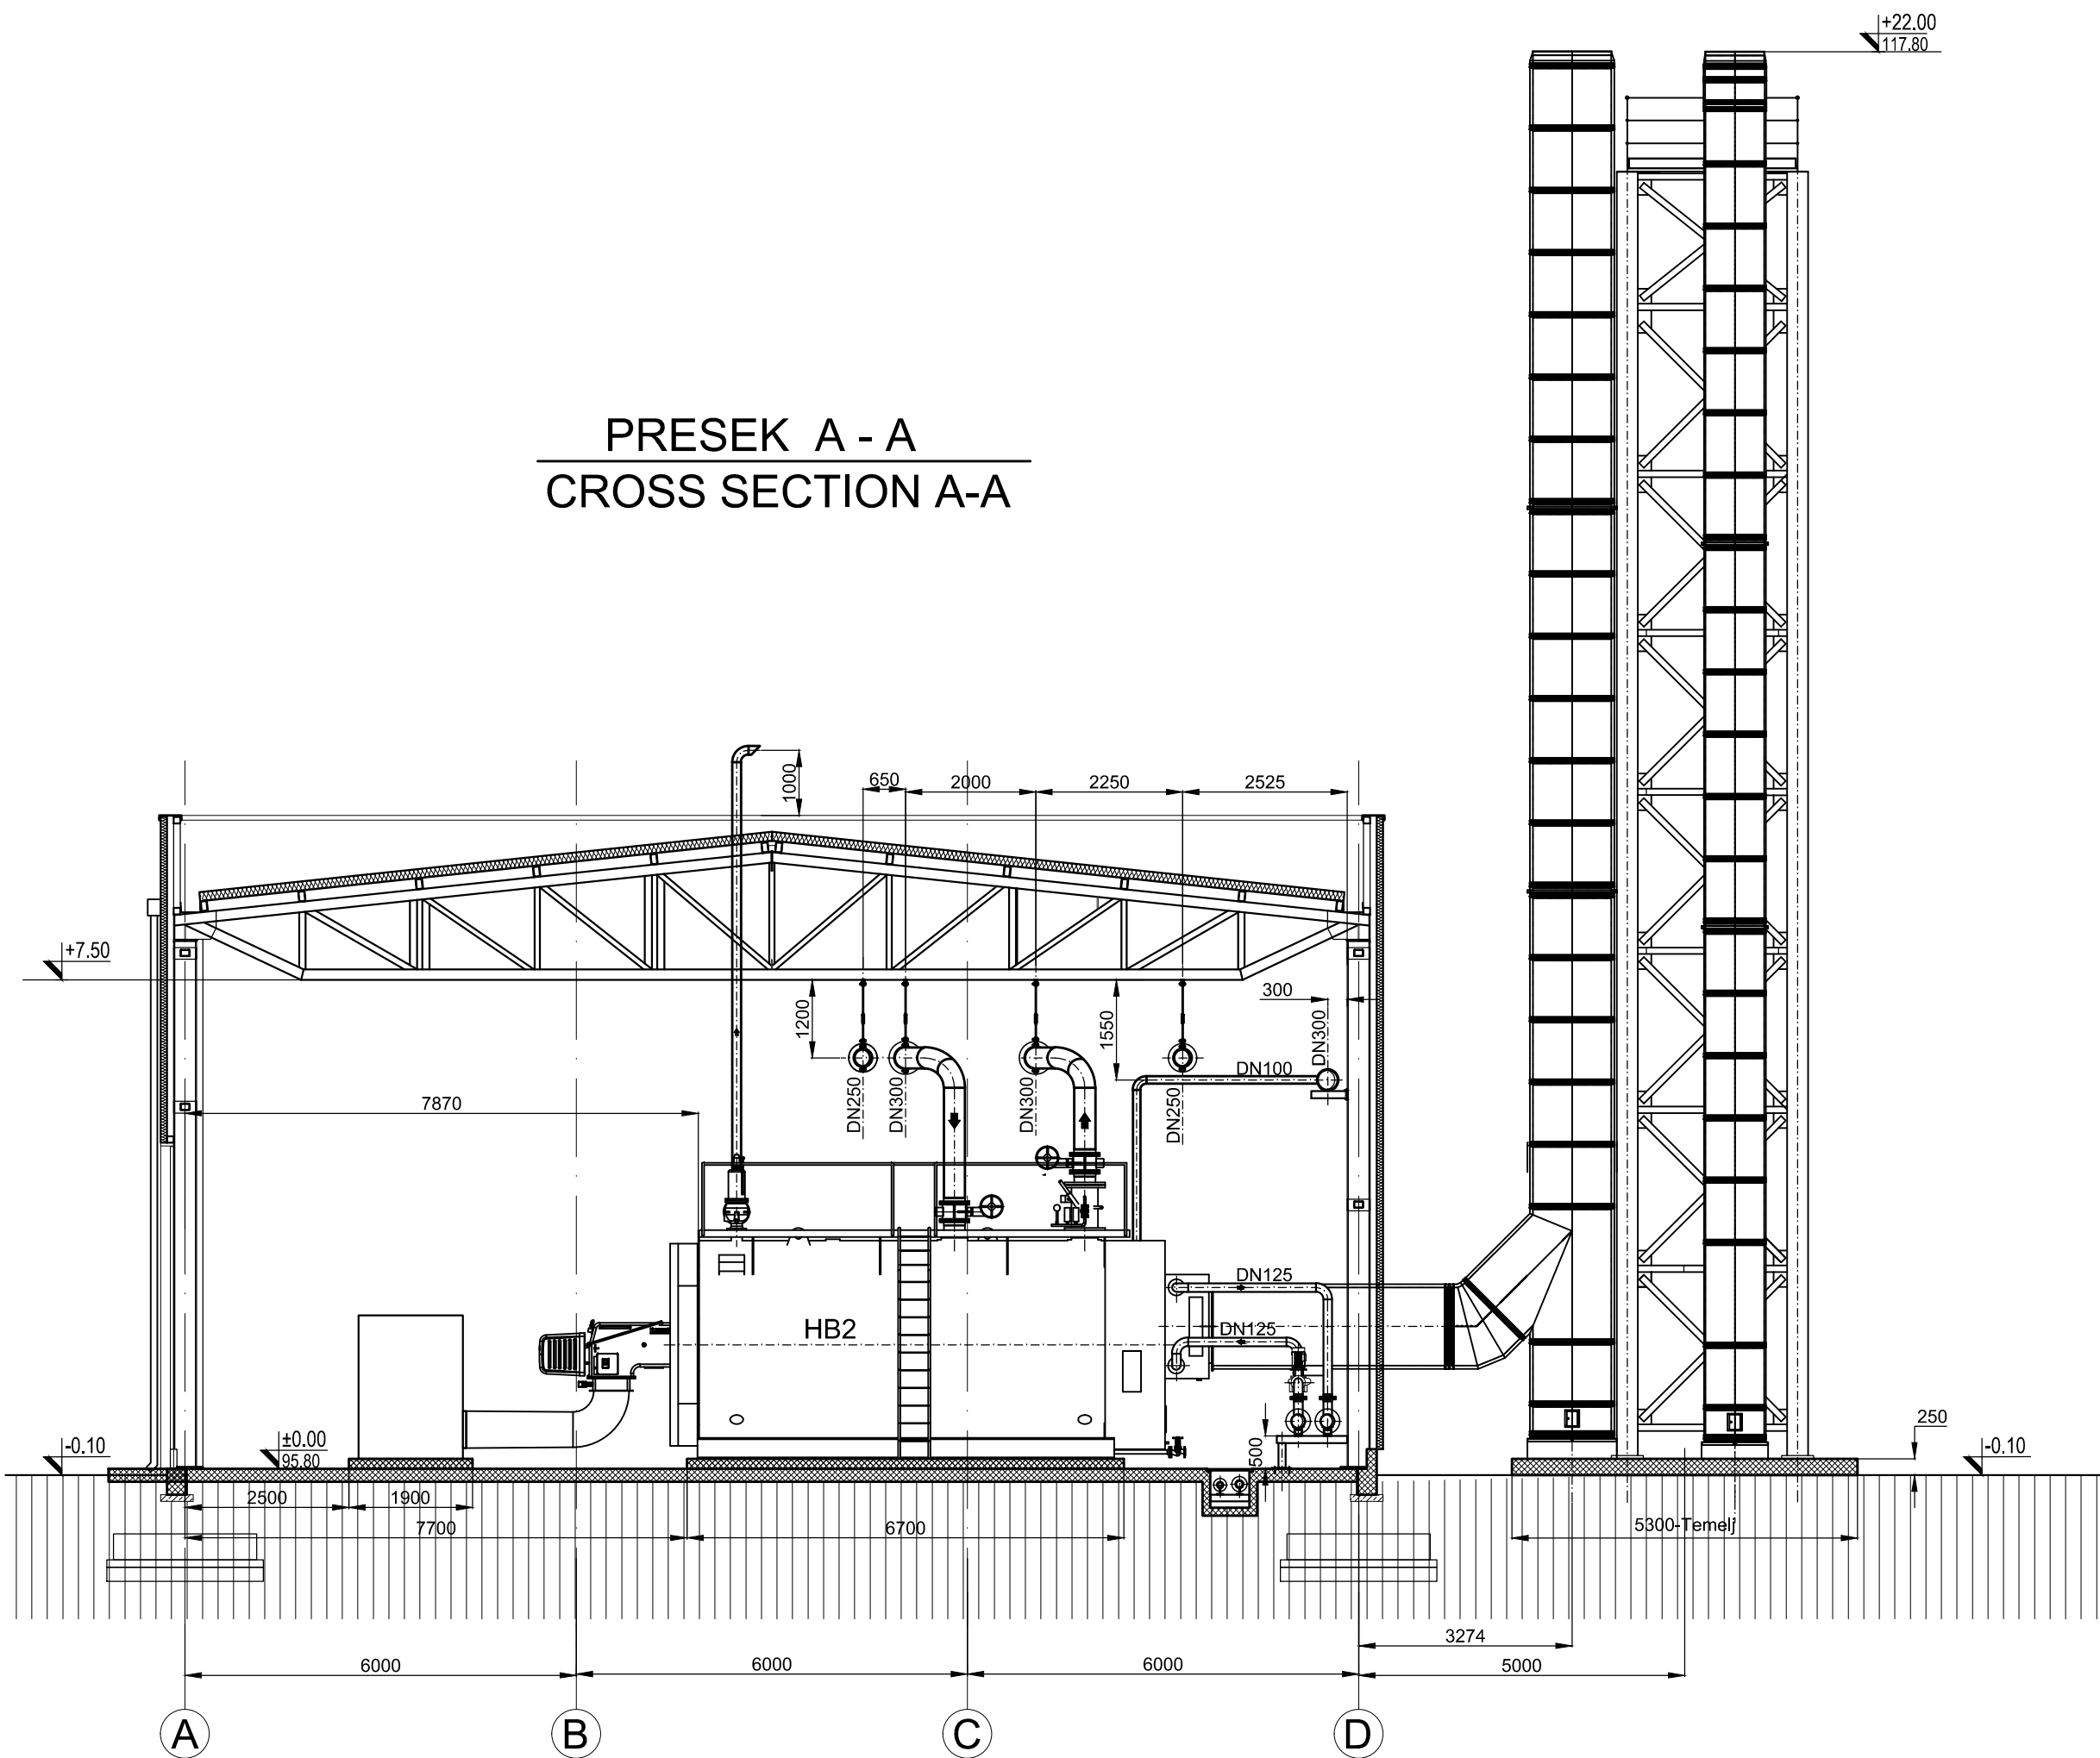




A01	09/08/2019	PRVO IZDANJE		
		FIRST EMISSION		
Rev.	Datum	OPIS IZMENE	Inicijali	Pečat
Rev.	Date	EXPLANATORY NOTE REGARDING MODIFICATIONS	Initials	Signat.

NIKOLA TESLA AIRPORT CONCESSION, BELGRADE - SERBIA
NIKOLA TESLA AERODROM KONCESIJA, BEOGRAD - SRBIJA

 
 
REPUBLIC OF SERBIA REPRESENTED BY: PREDSTAVNIK REPUBLIKE SRBIJE:	GRANTOR / INVESTOR GRANTOR / INVESTITOR	CONCESSIONAIRE / FINANCIER KONCESIONAR / FINANSIJER
		 VINCI AIRPORTS SERBIA D.O.O. 11180 Beograd 59, Surčin

  	CONTRACTOR IZVOĐAČ RADOVA	SUB-CONTRACTOR PODIZVOĐAČ RADOVA
 ENERGOPROJEKT INDUSTRY P.L.C. BELGRADE, SERBIA		

CONTRACTOR IZVOĐAČ RADOVA	CONCESSIONAIRE KONCESIONAR	TECHNICAL CONTROL TEHNIČKA KONTROLA	OTHER OSTALO
------------------------------	-------------------------------	--	-----------------

DOCUMENT TITLE NAZIV DOKUMENTA	CROSS SECTION A-A PRESEK A-A
-----------------------------------	---------------------------------

DOCUMENT CODE BROJ DOKUMENTA										
ANT	IDP	64	THP	EPI	HEP	X	DS	P1	0004	A01
Project Projekat	Stage Faza	Book Knjiga	Discipline Oblast	Issuer Emitent	Location Lokacija	Level Sprat	Type Tip	Phasing Etapa	Number Broj	Revision Revizija

CONTRACT UGOVOR	NAME AND SURNAME IME I PREZIME	SIGNATURE POTPIS	PROJECT / OBJECT NAZIV OBJEKTA
2619-EI/18			AIRPORT NIKOLA TESLA NEW HEATING PLANT AERODROM NIKOLA TESLA NOVA KOTLARница
CHIEF DESIGNER ODGOVORNI PROJEKTANT	Stevo Ilić, d.i.m. 330 8624 04		STAGE / FAZA PROJEKTA
DESIGNER'S ASSOCIATE SARADNIK			BASIC DESIGN IDEJNI PROJEKAT
INTERNAL CONTROLLER UNUTRAŠNJA KONTROLA	Vladan Obradović, d.i.m. 330 3911 03		DISCIPLINE / OBLAST
PROJECT MANAGER ŠEF PROJEKTA	Stojanka Pejičić, d.i.e. 350 1886 10		6/2 - Thermal Power Design 6/2 - Projekat termoeenergetike
DESIGN NUMBER / BROJ PROJEKTA	SCALE / RAZMERA	DATE / DATUM	DRAWING NAME / NAZIV CRTEŽA
ZEI201918	1:100	VIII 2019	Cross Section A-A Presek A-A
			DRAWING NUMBER / BROJ CRTEŽA
			idp 6/2 MST - 004
			Sheet / Strana
			1
			Sheet / Strana
			1