


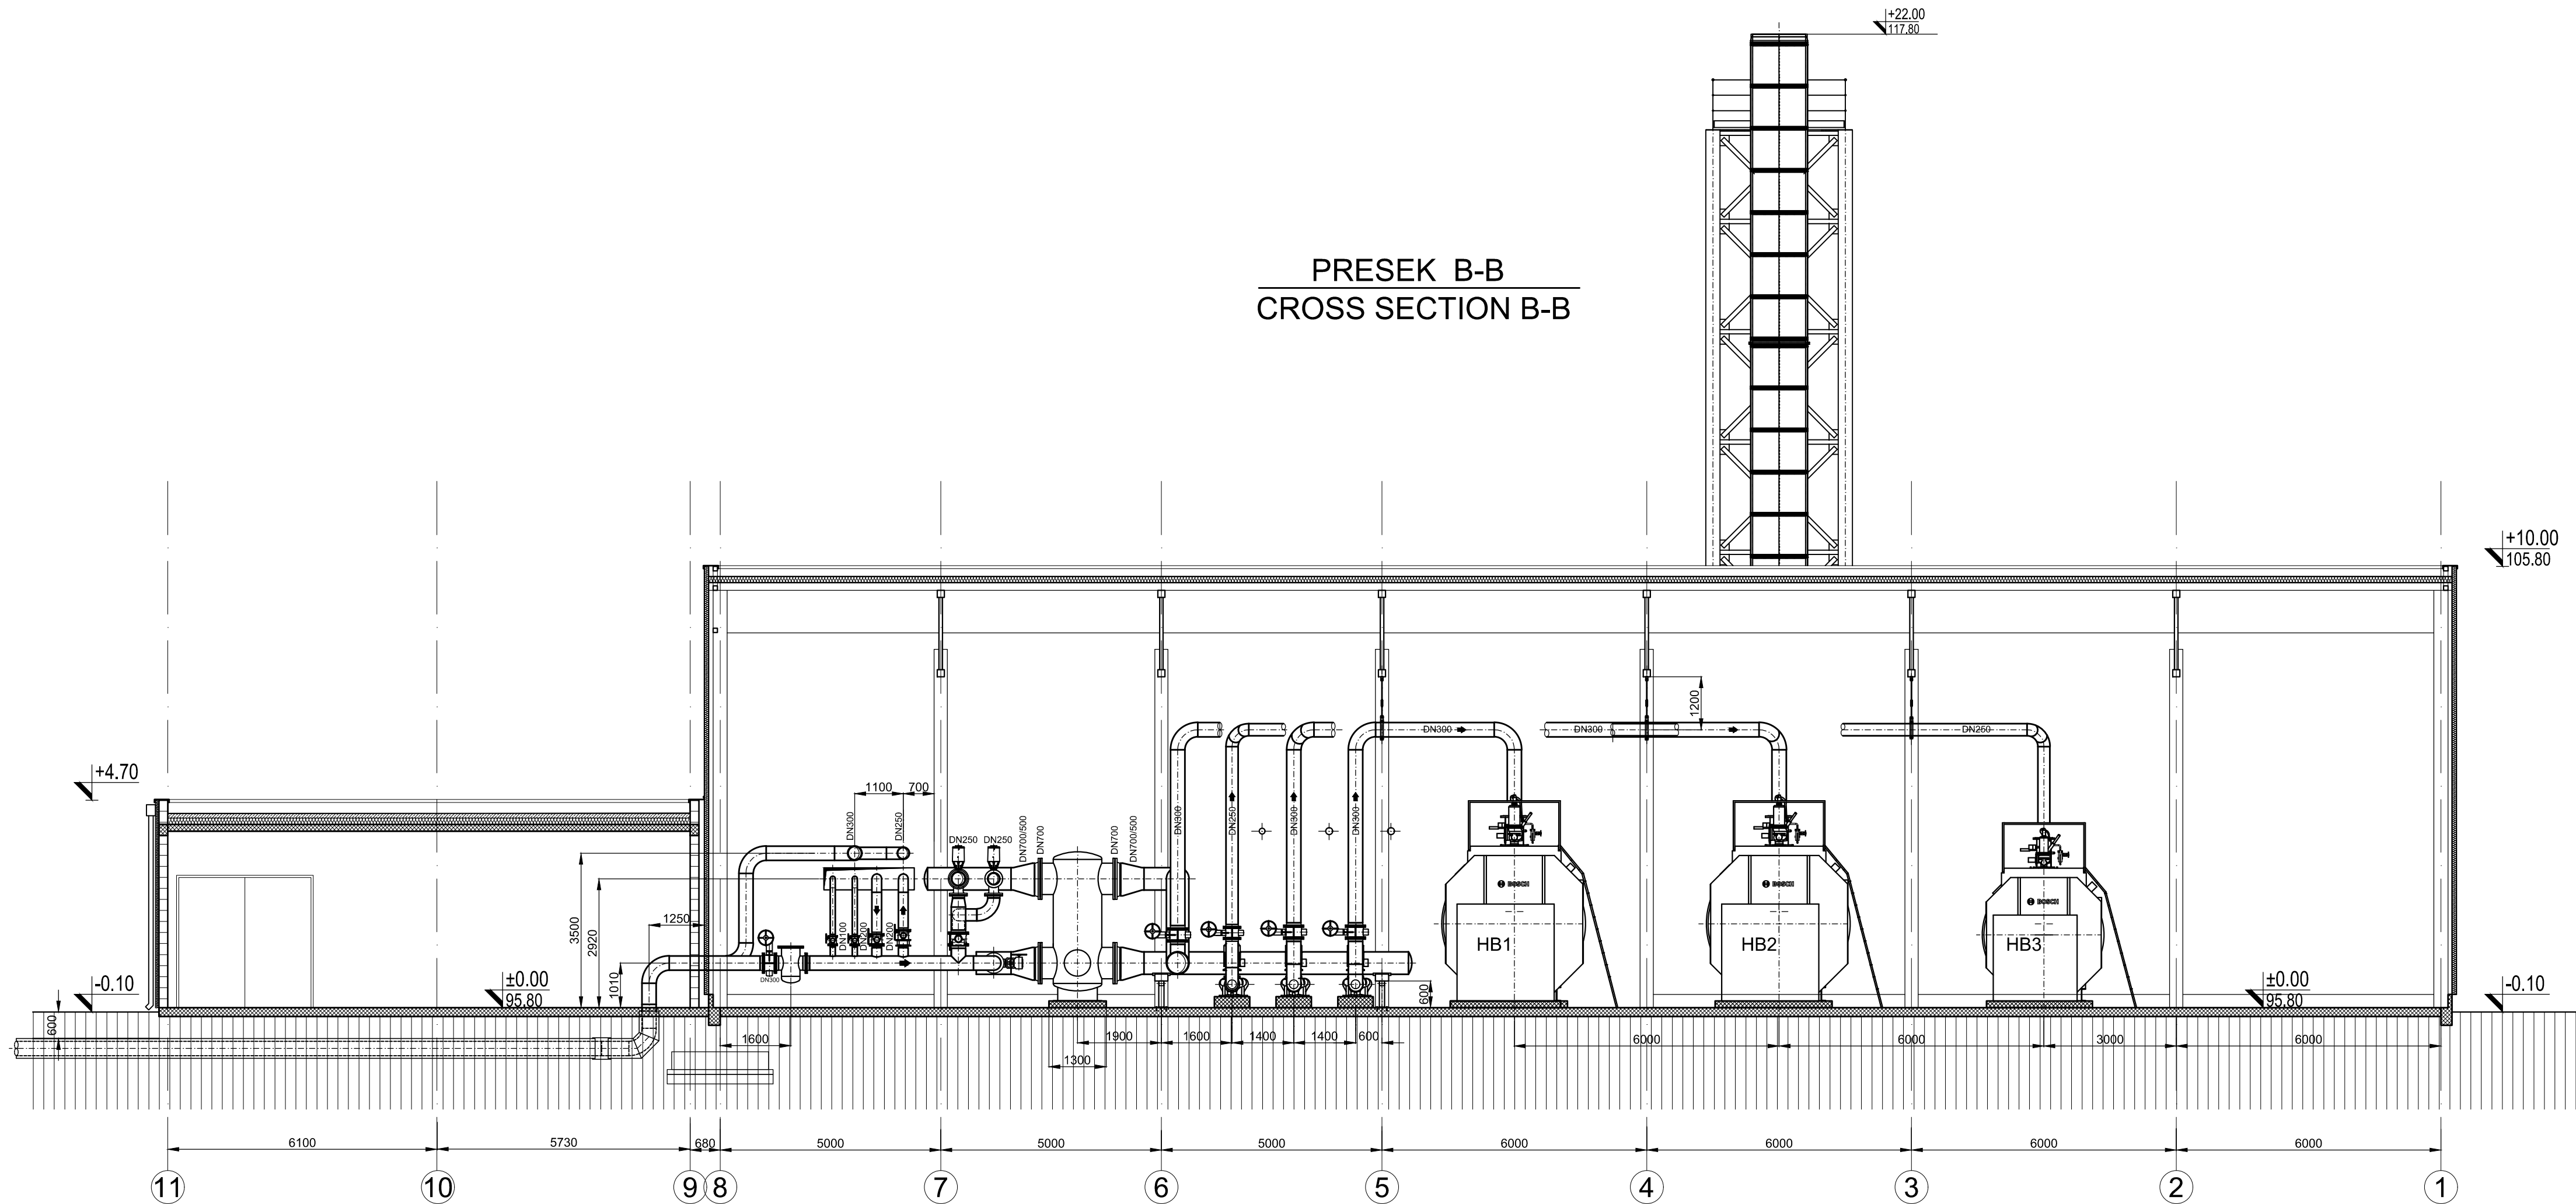

A01	09/08/2019	PRVO IZDANJE FIRST EMISSION		
	Rev.	Datum	OPIS IZMENE	inicijali Initials
Rev.	Date	EXPLANATORY NOTE REGARDING MODIFICATIONS		Pečat Signat.

NIKOLA TESLA AIRPORT CONCESSION, BELGRADE - SERBIA
NIKOLA TESLA AERODROM KONCESIJA, BEOGRAD - SRBIJA

REPUBLIC OF SERBIA REPRESENTED BY: PREDSTAVNIK REPUBLIKE SRBIJE	GRANTOR / INVESTOR GRANTOR / INVESTITOR	CONCESSIONAIRE / FINANCIER KONCESIONAR / FINANSIJER
		VINCI AIRPORTS SERBIA D.O.O. 11180 Beograd 59, Surčin

CONTRACTOR IZVOĐAČ RADOVA	CONCESSIONAIRE KONCESIONAR	TECHNICAL CONTROL TEHNIČKA KONTROLA	OTHER OSTALO
		ENERGOPROJEKT INDUSTRY P.L.C. BELGRADE, SERBIA	

CONTRACTOR IZVOĐAČ RADOVA	CONCESSIONAIRE KONCESIONAR	TECHNICAL CONTROL TEHNIČKA KONTROLA	OTHER OSTALO
------------------------------	-------------------------------	--	-----------------

DOCUMENT TITLE NAZIV DOKUMENTA	CROSS SECTION B-B PRESEK B-B
-----------------------------------	---------------------------------

DOCUMENT CODE BROJ DOKUMENTA	ANT IDP 64 THP EPI HEP X DS P1 0005 A01
Project Projekat	Stage Faza
Book Knjiga	Discipline Oblast
Issuer Emitent	Location Lokacija
Level Sprat	Type Tip
Phasing Etapa	Number Broj
Revision Revizija	

CONTRACT UGOVOR	NAME AND SURNAME IME I PREZIME	SIGNATURE POTPIS	PROJECT / OBJECT NAZIV OBJEKTA
2619-EI/18			AIRPORT NIKOLA TESLA NEW HEATING PLANT AERODROM NIKOLA TESLA NOVA KOTLARница
CHIEF DESIGNER ODGOVORNI PROJEKTANT	Stevo Ilić, d.l.m. 330 8624 04		STAGE / Faza PROJEKTA
DESIGNER'S ASSOCIATE SARADNIK			BASIC DESIGN IDEJNI PROJEKAT
INTERNAL CONTROLLER UNUTRAŠNJA KONTROLA	Vladan Obradović, d.l.m. 330 3811 03		DISCIPLINE / OBLAST
PROJECT MANAGER ŠEF PROJEKTA	Stojanka Pejčić, d.l.e. 350 1886 10		6/2 - Thermal Power Design 6/2 - Projekat termoenergetike
DESIGN NUMBER / BROJ PROJEKTA	SCALE / MERIL	DATE / DATUM	DRAWING NAME / NAZIV CRTEŽA
ZEI201918	1:100	VIII 2019	Cross Section B-B Presek B-B
			DRAWING NUMBER / BROJ CRTEŽA
			idp 6/2 MST - 005
			Sheet / Strana
			1
			Sheet / Strana
			1