


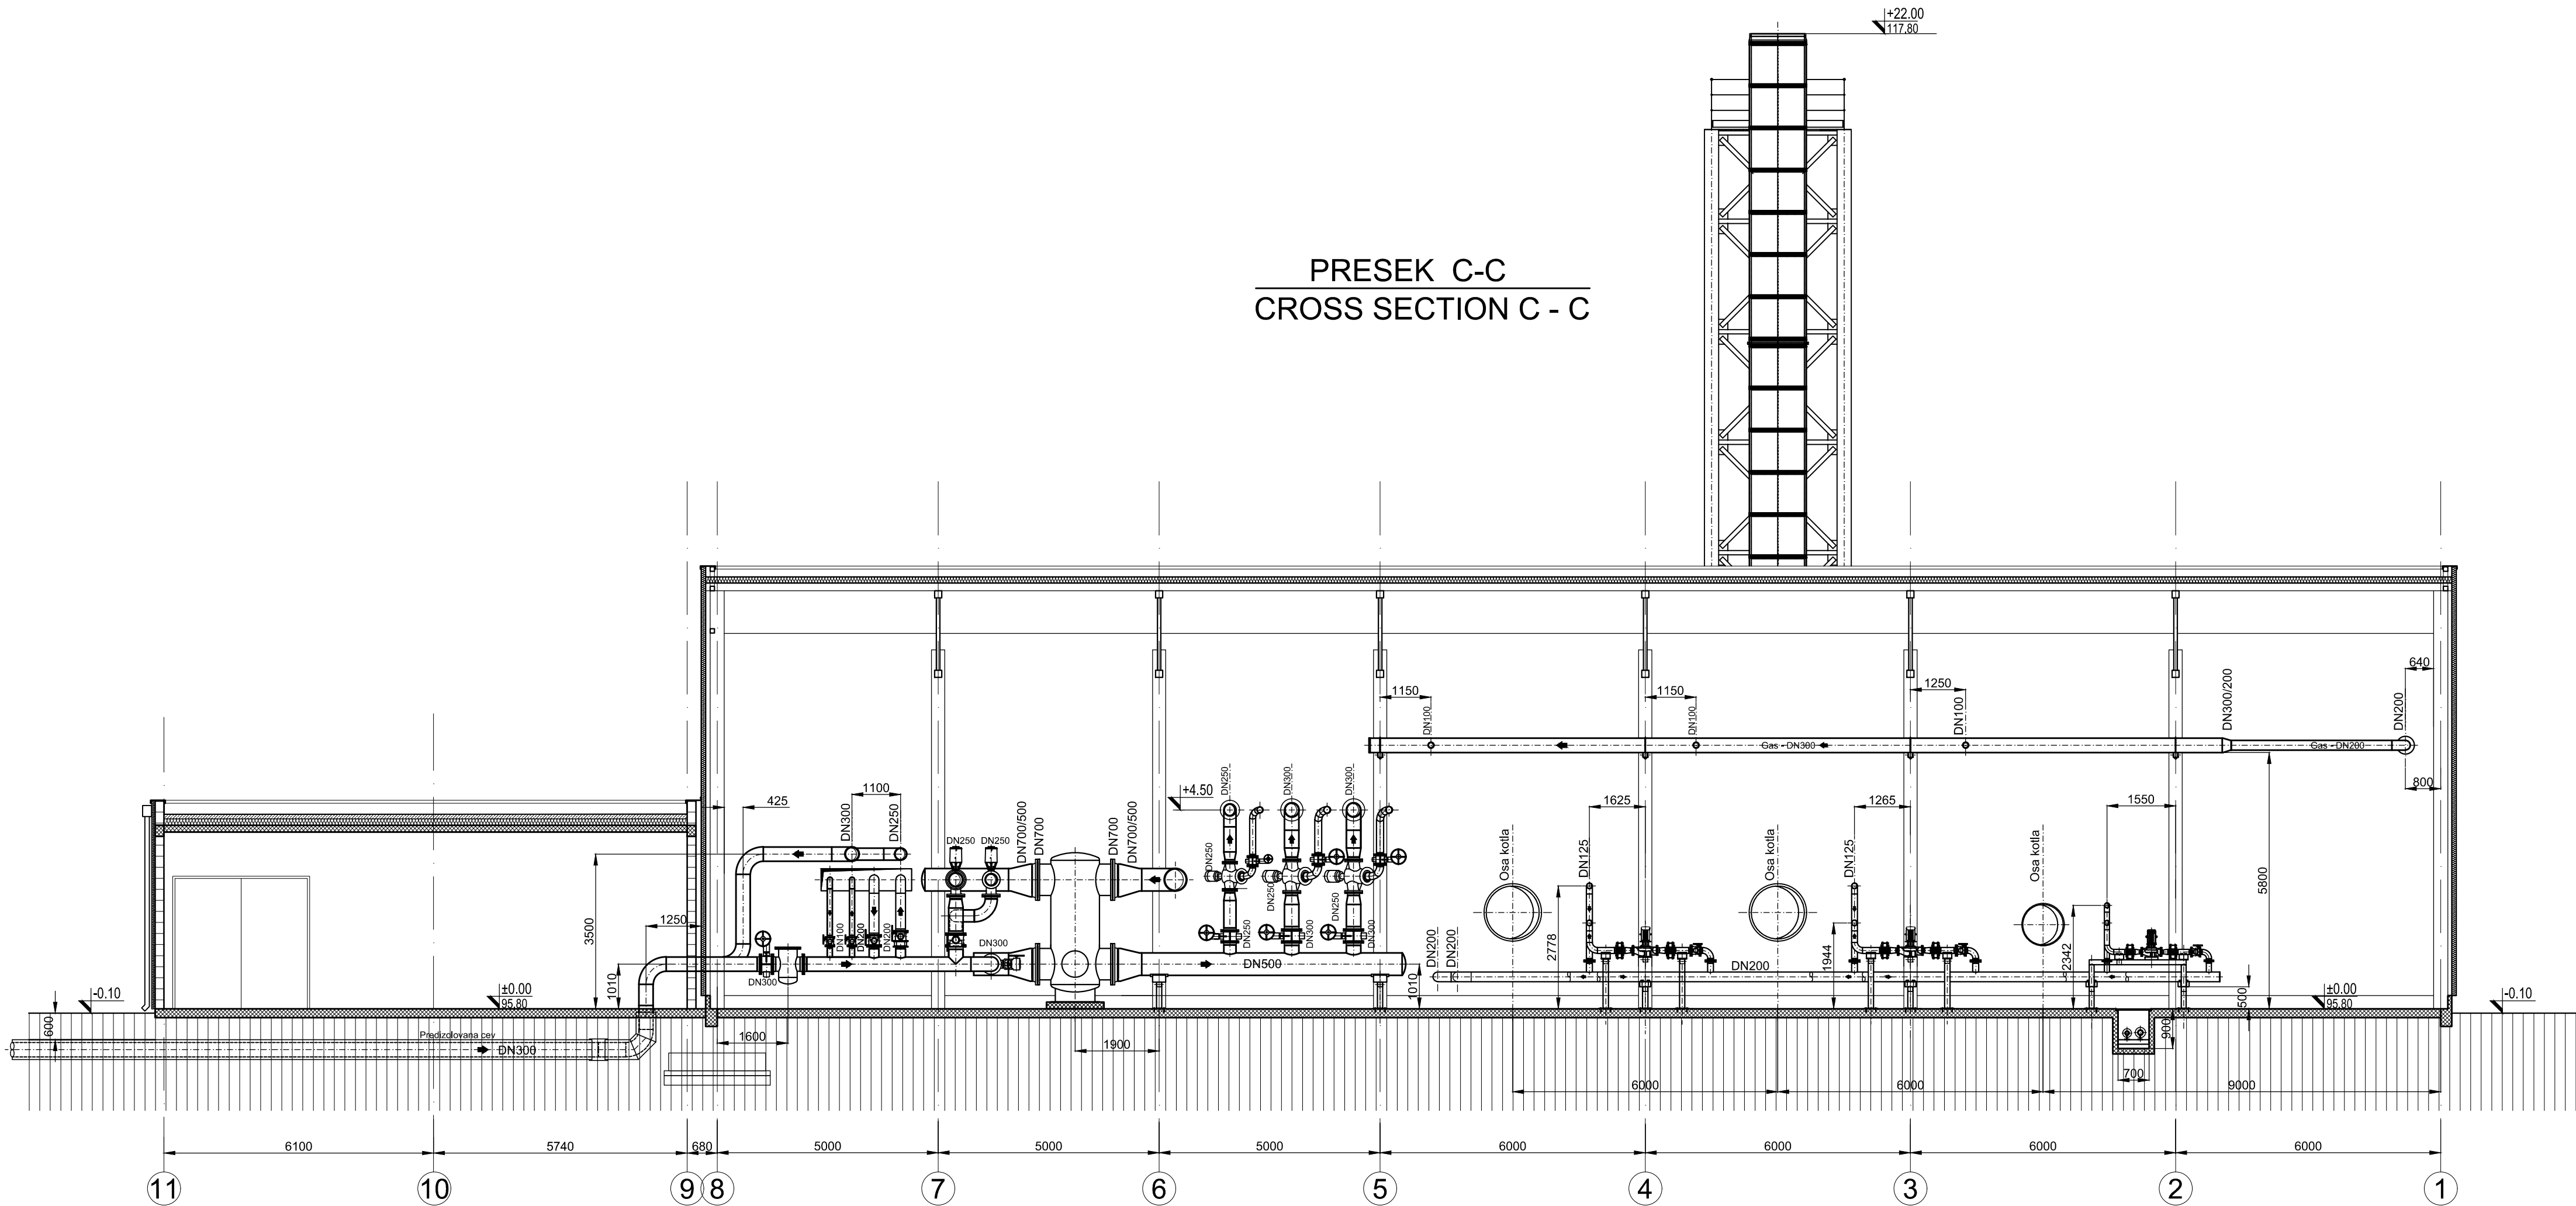

A01	09/08/2019	PRVO IZDANJE FIRST EMISSION		
		OPIS IZMENE		
Rev.	Datum	OPIS IZMENE	Inicijali	Pečat
Rev.	Date	EXPLANATORY NOTE REGARDING MODIFICATIONS	Initials	Signat.

NIKOLA TESLA AIRPORT CONCESSION, BELGRADE - SERBIA
NIKOLA TESLA AERODROM KONCESIJA, BEOGRAD - SRBIJA

REPUBLIC OF SERBIA REPRESENTED BY: PREDSTAVNIK REPUBLIKE SRBIJE		GRANTOR / INVESTOR GRANTOR / INVESTITOR		CONCESSIONAIRE / FINANCIER KONCESIONAR / FINANSIJER		
 REPUBLIKA SRBIJA POSREDOVANJE U PROMETU NEPOKRETNOSTI		 Aerodrom Nikola Tesla Beograd		 VINCI AIRPORTS SERBIA D.O.O 11180 Beograd 59, Surčin		
		CONTRACTOR IZVOĐAČ RADOVA		SUB-CONTRACTOR PODIZVOĐAČ RADOVA		
 VINCI AIRPORTS		 TERNAR S.A. TERNAR GR		 ENERGOPROJEKT INDUSTRY P.L.C. BELGRADE, SERBIA		
STATUS / STATUS	CONTRACTOR IZVOĐAČ RADOVA		CONCESSIONAIRE KONCESIONAR		TECHNICAL CONTROL TEHNIČKA KONTROLA	
					OTHER OSTALO	
	DOCUMENT TITLE NAZIV DOKUMENTA					
	DOCUMENT CODE BROJ DOKUMENTA					
CROSS SECTION C-C PRESEK C-C						
DOCUMENT CODE BROJ DOKUMENTA						
ANT IDP 64 THP EPI HEP X DS P1 0006 A01						
Project Projekat Stage Faza Book Knjiga Discipline Oblast Issuer Emitent Location Lokacija Level Sprat Type Tip Phasing Etapa Number Broj Revision Revizija						
CONTRACT UGOVOR		NAME AND SURNAME IME I PREZIME		SIGNATURE POTPIS		
2619-EI/18				PROJECT / OBJECT NAZIV OBJEKTA		
				AIRPORT NIKOLA TESLA NEW HEATING PLANT AERODROM NIKOLA TESLA - NOVA KOTLARница		
CHIEF DESIGNER ODGOVORNI PROJEKTANT		Stevo Ilić, d.l.m. 330 8624 04		STAGE / FAZA PROJEKTA		
DESIGNER'S ASSOCIATE SARADNIK				DISCIPLINE / OBLAST		
				BASIC DESIGN IDEJNI PROJEKAT		
				6/2 - Thermal Power Design 6/2 - Projekat termoelektre		
INTERNAL CONTROLLER UNUTRAŠNJA KONTROLA		Vladan Obradović, d.l.m. 330 3911 03		DRAWING NAME / NAZIV CRTEŽA		
PROJECT MANAGER ŠEF PROJEKTA		Stojanka Pejčić, d.l.e. 350 1886 10		Cross Section C-C Presek C-C		
DESIGN NUMBER / BROJ PROJEKTA ZEI201918		SCALE / RAZMERA 1:100		DRAWING NUMBER / BROJ CRTEŽA idp 6/2 MST - 006		
				Sheet / Strana 1		