



PRESEK D-D
CROSS SECTION D-D

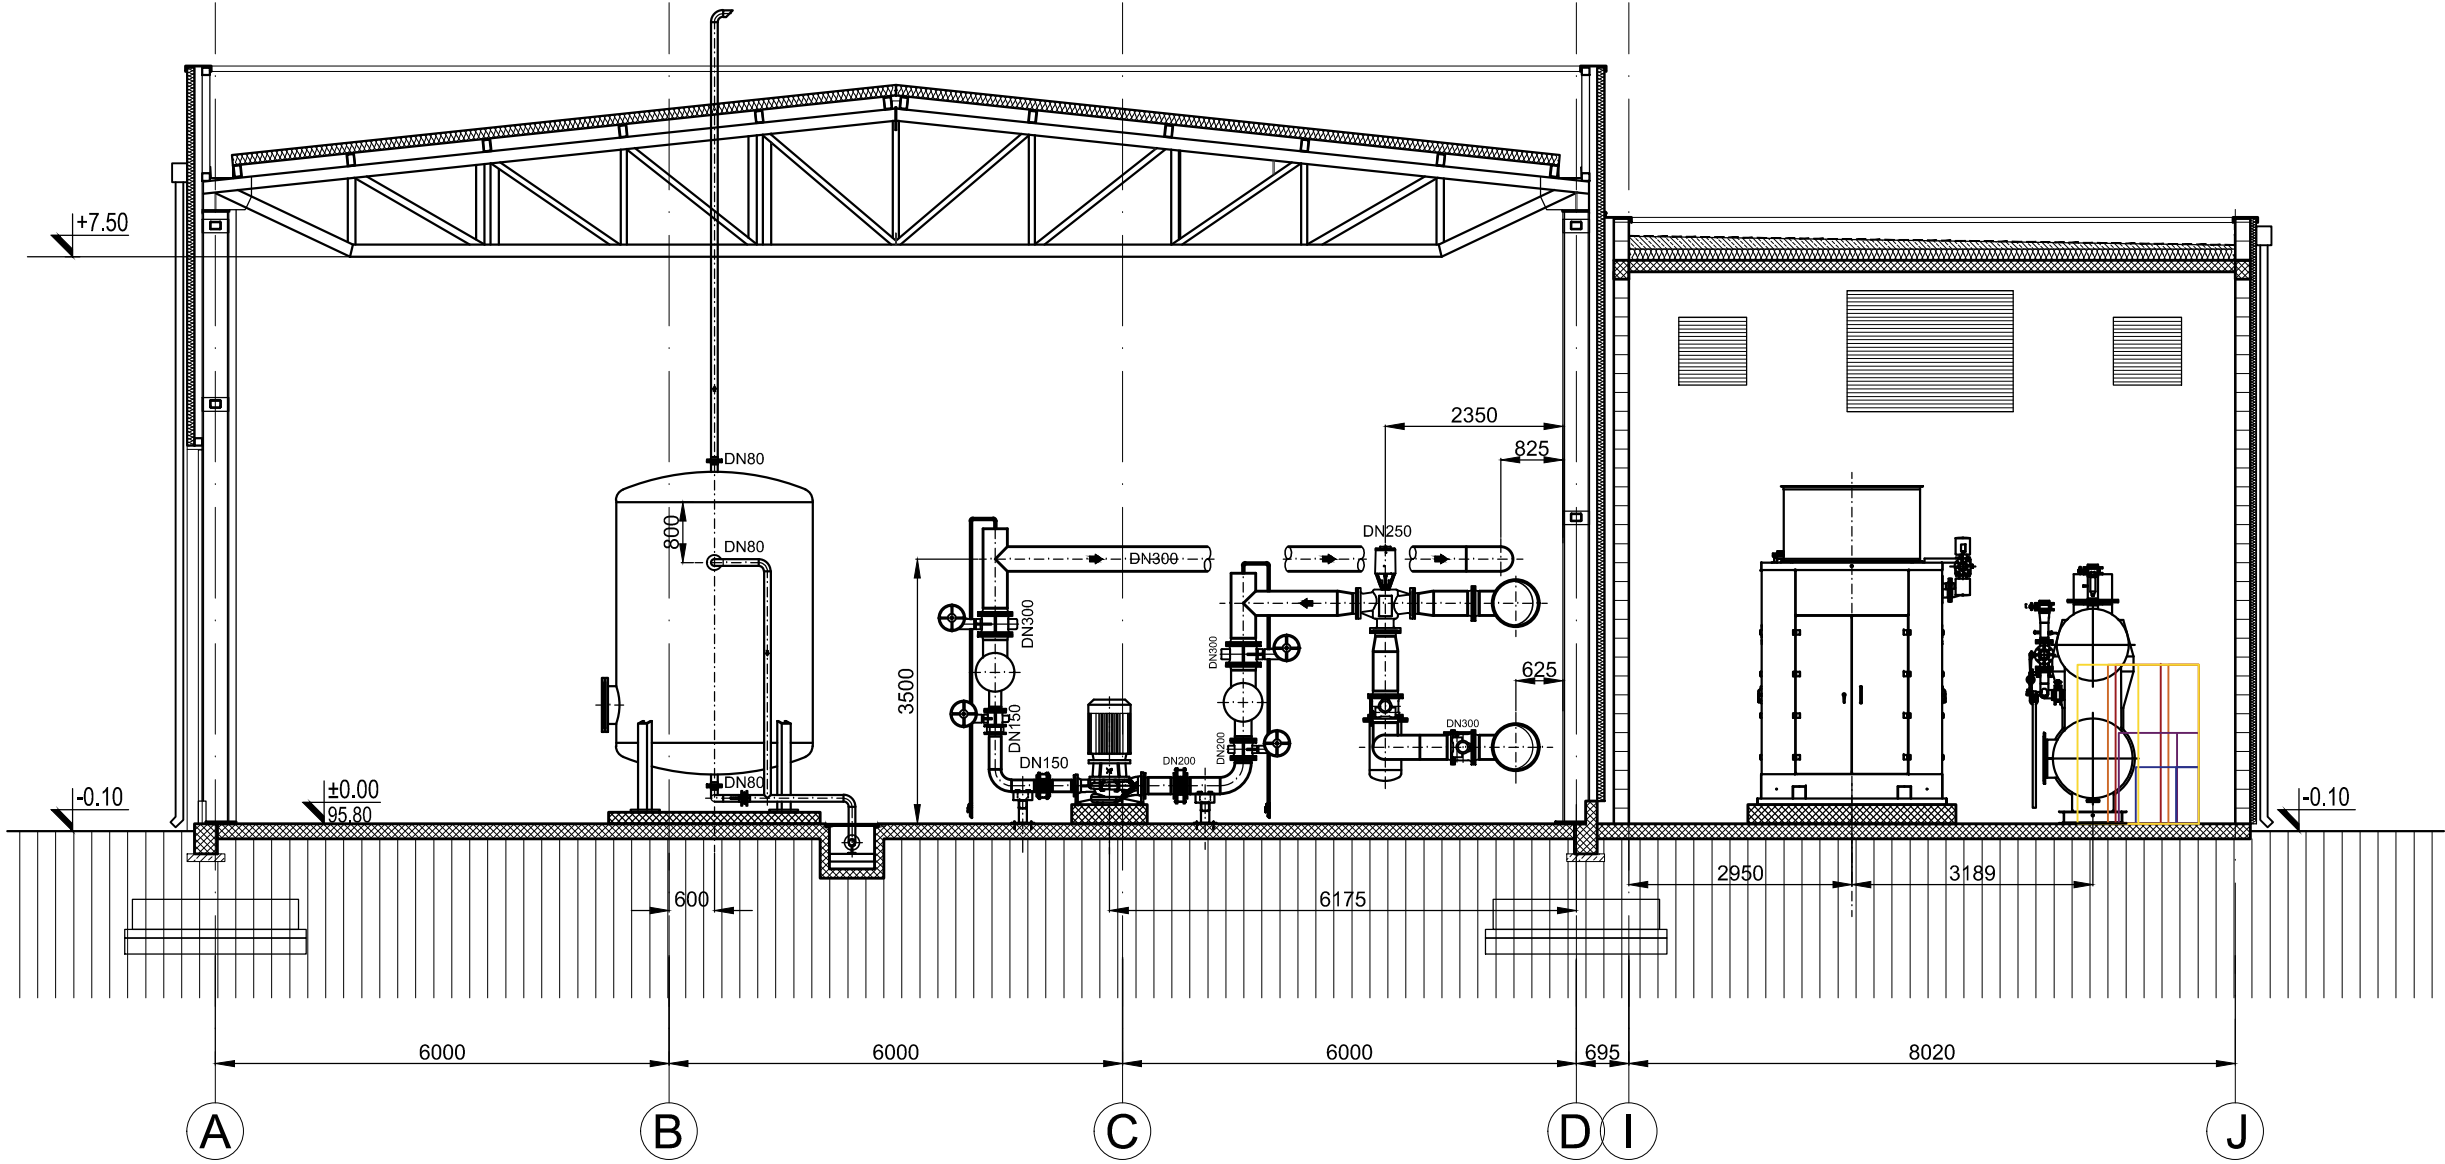

PRESEK E-E
CROSS SECTION E-E

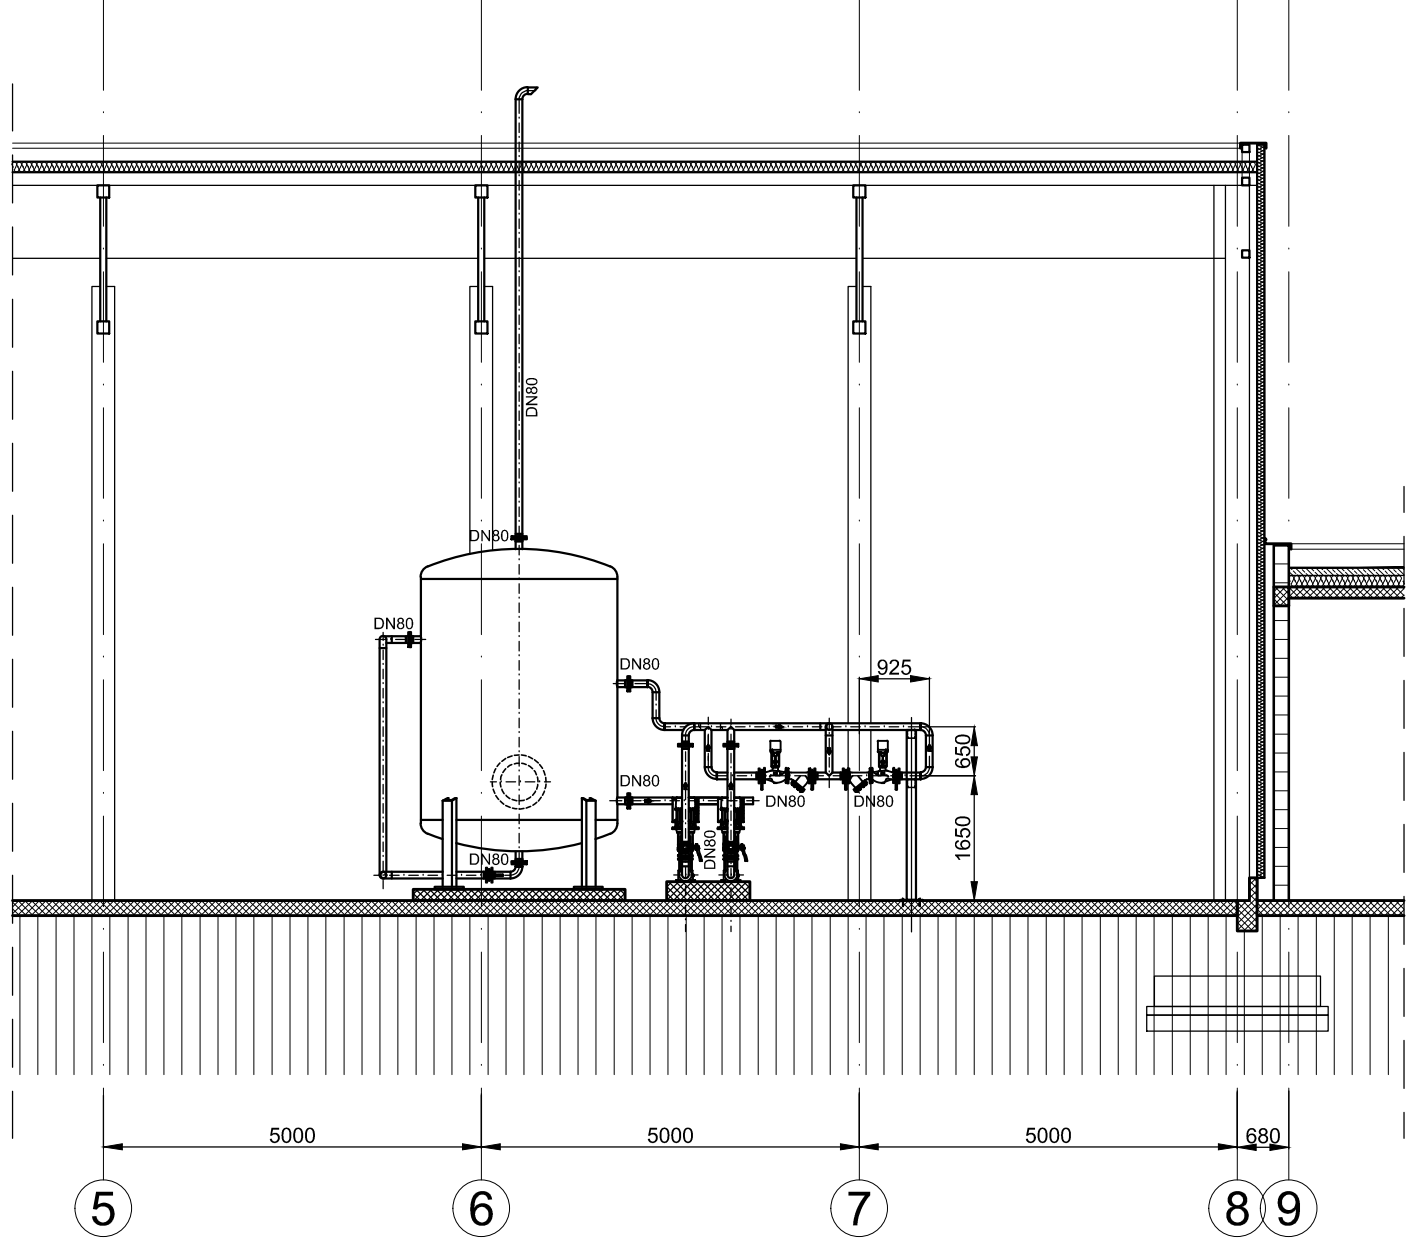

A01	09/08/2019	PRVO IZDANJE		
		FIRST EMISSION		
Rev.	Datum	OPIS IZMENE	Inicijali	Pečat
Rev.	Date	EXPLANATORY NOTE REGARDING MODIFICATIONS	Initials	Signat.

NIKOLA TESLA AIRPORT CONCESSION, BELGRADE - SERBIA
NIKOLA TESLA AERODROM KONCESIJA, BEOGRAD - SRBIJA

REPUBLIC OF SERBIA REPRESENTED BY: PREDSTAVNIK REPUBLIKE SRBIJE:		GRANTOR / INVESTOR GRANTOR / INVESTITOR		CONCESSIONAIRE / FINANCIER KONCESIONAR / FINANSIJER	
 REPUBLIKA SRBIJA MINISTARSTVO PROMETA I PROMETNOPOSREDOVANJE POSREDOVANJE U PROMETU NEPOKRETNOSTI		 Aerodrom Nikola Tesla Beograd		 VINCI AIRPORTS SERBIA D.O.O 11180 Beograd 59, Surcin	
 VINCI CONSTRUCTION		 GRANDS PROJETS		 TERNAS	
CONTRACTOR IZVOĐAČ RADOVA		SUB-CONTRACTOR PODIZVOĐAČ RADOVA			
 ENERGOPROJEKT INDUSTRY P.L.C. BELGRADE, SERBIA					
CONTRACTOR IZVOĐAČ RADOVA		CONCESSIONAIRE KONCESIONAR		TECHNICAL CONTROL TEHNIČKA KONTROLA	
				OTHER OSTALO	
DOCUMENT TITLE NAZIV DOKUMENTA					
CROSS SECTIONS D-D AE-E PRESEK D-D AE-E					
DOCUMENT CODE BROJ DOKUMENTA					
ANT IDP 64 THP EPI HEP X DS P1 0007 A01					
Project Stage Book Discipline Issuer Location Level Type Phasing Number Revision Projekat Faza Knjiga Oblast Emitent Lokacija Sprat Tip Etapa Broj Revizija					
CONTRACT UGOVOR		NAME AND SURNAME IME I PREZIME		SIGNATURE POTPIS	
2619-EI/18					
CHIEF DESIGNER ODGOVORNI PROJEKTANT		Stevo Ilić, d.i.m. 330 8624 04		PROJECT / OBJECT NAZIV OBJEKTA	
DESIGNER'S ASSOCIATE SARADNIK				AIRPORT NIKOLA TESLA NEW HEATING PLANT AERODROM NIKOLA TESLA NOVA KOTLARница	
INTERNAL CONTROLLER UNUTRAŠNJA KONTROLA		Vladan Obradović, d.i.m. 330 3911 03		STAGE / FAZA PROJEKTA	
PROJECT MANAGER ŠEF PROJEKTA		Stojanka Pejčić, d.i.e. 350 1886 10		BASIC DESIGN IDEJNI PROJEKAT	
DESIGN NUMBER / BROJ PROJEKTA		SCALE / RAZMERA		DISCIPLINE / OBLAST	
ZEI201918		1:100		6/2 - Thermal Power Design 6/2 - Projekat termoeenergetike	
		DATE / DATUM		DRAWING NAME / NAZIV CRTEŽA	
		VIII 2019		CROSS SECTION D-D AE-E PRESEK D-D AE-E	
DRAWING NUMBER / BROJ CRTEŽA				Sheet / Strana	
idp 6/2 MST - 007				1	
				Sheets / Strane	
				1	