



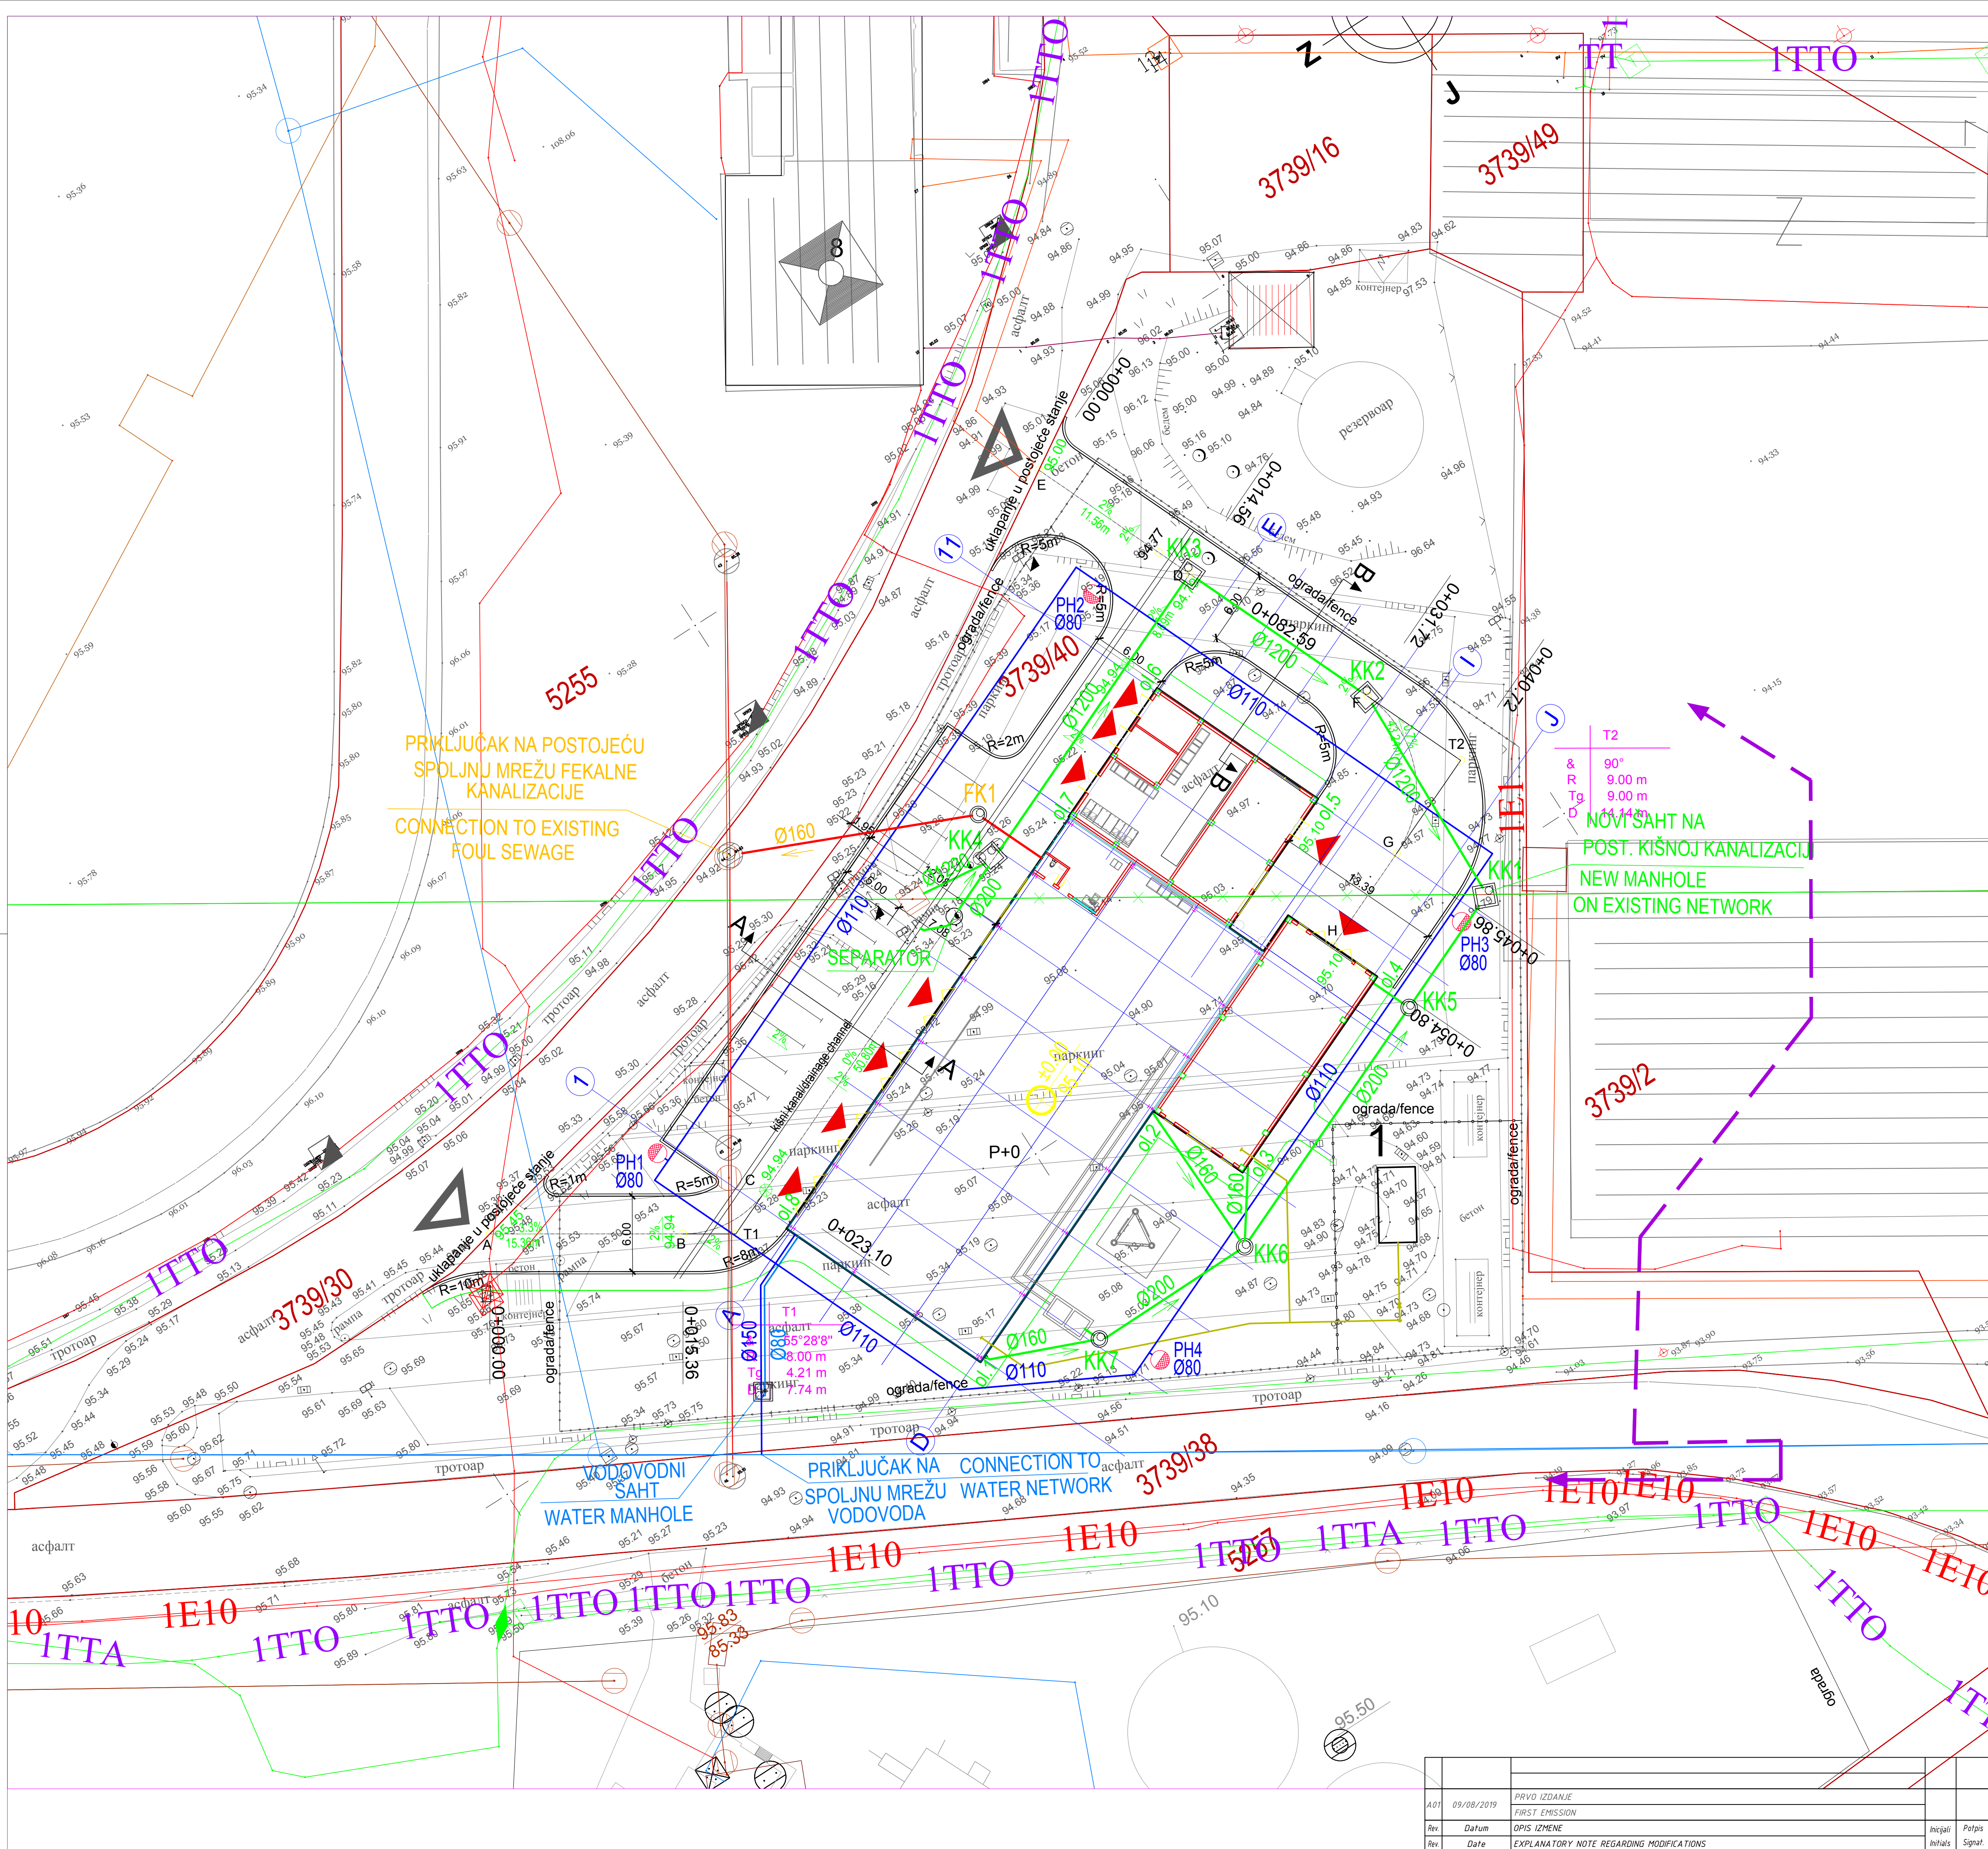

LEGENDA

1. NOVA KOTLARница/New Heating Plant

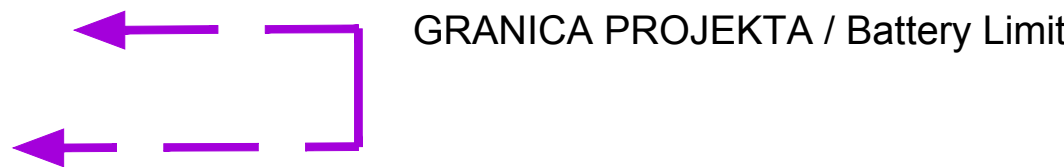

OGRADA / Fence

PARCELACIJA / Plot line

ULAZ U OBJEKAT / Building entrance

PRISTUP PARCELI / Plot entrance

LEGEND / LEGENDA
NEW / NOVOPROJEKTOVANO

FOUL SEWAGE - NEW
FEKALNA KANALIZACIJA - NOVOPROJEKTOVANA

FOUL SEWAGE - EXISTING
FEKALNA KANALIZACIJA - POSTOJEĆA

OUTDOOR RAIN SEWAGE - NEW
SPOLJAŠNJA KIŠNA KANALIZACIJA - NOVOPROJEKTOVANA

OUTDOOR RAIN SEWAGE - DEMOLISH
SPOLJAŠNJA KIŠNA KANALIZACIJA - UKIDA SE

SANITARY NETWORK - NEW
SANITARNA MREŽA - NOVOPROJEKTOVANA

HYDRANT NETWORK - NEW
HIDRANTSKA MREŽA - NOVOPROJEKTOVANA

WATER SUPPLY NETWORK - EXISTING
VODOVODNA MREŽA - POSTOJEĆA

NIKOLA TESLA AIRPORT CONCESSION, BELGRADE - SERBIA
NIKOLA TESLA AERODROM KONCESIJA, BEOGRAD - SRBIJA

REPUBLIC OF SERBIA REPRESENTED BY:
PREDSTAVNIK REPUBLIKE SRBIJE



GRANTOR / INVESTOR
GRANTOR / INVESTITOR



±0.00 = 95.10

CONCESSIONAIRE / FINANCIER
KONCESIONAR / FINANSIJER



BELGRADE AIRPORT d.o.o.
11180 Beograd 59, Surčin



GRANDS PROJETS



SEE TERNIA GROUP



ENERGOPROJEKT
INDUSTRY P.L.C.
BEOGRAD, SERBIA

CONTRACTOR
IZVOĐAČ RADOVA

CONCESSIONAIRE
KONCESIONAR

TECHNICAL CONTROL
TEHNIČKA KONTROLA

OTHER
OSTALO

LAYOUT WITH LEVELING PLAN
SITUACIONO-NIVELACIONI PLAN

ANT IDP 03 PLB EPI HEP X DP P1 0001 B 01

Project Stage Book Discipline Issuer Location Layer Type Phasing Number Revision

CONTRACT USLOV 2619-EI/18 NAME AND SURNAME IME I PREZIME D.Janjićević, d.i.g. 314 1266 09 BODILJE POJME D.Janjićević, d.i.g. 314 1266 09 PROJECT / OBJEKT NAZIV OBJEKTA AIRPORT NIKOLA TESLA New Heating Plant

CHIEF DESIGNER OSNOVNI PROJEKTANT S. Popović, grad. teh. DISCIPLINE/ODSLAST 3 - Plumbing Design

ASSOCIATE DESIGNER PROJEKTANT SARADNIK A.Košić, d.i.g. 314 1266 09 3 - Projekt hidrotehničkih instalacija

INTERNAL CONTROLLER UNUTRAŠNJA KONTROLA S. Popović, grad. teh. LAYOUT WITH LEVELING PLAN

PROJECT MANAGER ŠEF PROJEKTA Stojanica Pejčić, d.i.g. 350 1886 10 SITUACIONO-NIVELACIONI PLAN

DESIGN NUMBER / BROJ PROJEKTA ZE1201918 SCALE / RAZMERA 1:250 DATE / DATUM VIII 2019 DRAWING NUMBER / BROJ CRTEŽA idp 3 HI-001

Sheet / Strana 1

Rev	Datum	OPIS IZMENE	Rev	Initials	Signature
Rev	Date	EXPLANATORY NOTE REGARDING MODIFICATIONS	Rev	Initials	Signature